

C:\Users\patterson\Desktop\Tolleson\10582\100 Tolleson\10587 - Master Site Plan - Acm\ADMgroup\pnc.rvt

- 68 - Concrete - 35 - OFFSITE ADJ WAYS - CURB & GUTTER, VERT 6" MAG 220-1, A - 4,731 LF
- 114 - Concrete - 35 - OFFSITE ADJ WAYS - CURB & GUTTER, MOUNT 6" - 30 LF
- 115 - Concrete - 35 - OFFSITE ADJ WAYS - SIDEWALK, 4" MAG 230, 12' - 44,873 SF ; 3,739 LF
- 122 - Concrete - 35 - OFFSITE ADJ WAYS - RAMP, 4" MAG 236-1 - 517 SF
- 123 - Concrete - 35 - OFFSITE ADJ WAYS - DRIVE ENTRANCE, COA A1250-1 - 4,859 SF
- 124 - Concrete - 35 - OFFSITE ADJ WAYS - CURB, VERT - 72 LF
- 131 - Concrete - 35 - OFFSITE ADJ WAYS - DECEL LANE - 4,105 SF
- 132 - Concrete - 35 - OFFSITE ADJ WAYS - SIDEWALK, 4" MAG 230, 10' - 10,309 SF ; 1,031 LF
- 134 - Concrete - 35 - OFFSITE ADJ WAYS - SIDEWALK, 4" MAG 230, 06' - 555 SF ; 93 LF
- 135 - Concrete - 35 - OFFSITE ADJ WAYS - DRIVE ENTRANCE, COA A1252 - 326 SF
- 145 - Concrete - 22 - BUS LOOP & PARKING - CURB, VERTICAL MAG 222-A, ADJ WAYS - 1,659 LF
- 146 - Concrete - 22 - BUS LOOP & PARKING - CURB & GUTTER MAG 220-1 A, ADJ WAYS - 1,274 LF
- 148 - Concrete - 21 - NORTH PARKING LOT - CURB & GUTTER MAG 220-1 A, ADJ WAYS - 1,663 LF
- 150 - Concrete - 21 - NORTH PARKING LOT - CURB, VERTICAL MAG 222-A, ADJ WAYS - 2,282 LF
- 152 - Concrete - 20 - SOUTH PARKING LOT - CURB & GUTTER MAG 220-1 A, ADJ WAYS - 1,408 LF
- 154 - Concrete - 20 - SOUTH PARKING LOT - CURB, VERTICAL MAG 222-A, ADJ WAYS - 2,960 LF
- 155 - Concrete - 29 - WEST PRACTICE FIELD - CURB, VERTICAL MAG 222-A, ADJ WAYS - 417 LF
- 156 - Concrete - 29 - WEST PRACTICE FIELD - CURB & GUTTER MAG 220-1 A, ADJ WAYS - 448 LF
- 162 - Concrete - 21 - NORTH PARKING LOT - FIRE LANE, 7"1/4", ADJ WAYS - 6,171 SF
- 184 - Concrete - 20 - SOUTH PARKING LOT - CURB, ROLL CURB, ADJ WAYS - 55 LF
- 185 - Concrete - 20 - SOUTH PARKING LOT - SIDEWALK, FIRE LANE 7"1/4", ADJ WAYS - 340 SF
- 189 - Concrete - 18 - COURTYARD PH1 - FIRE LANE, 7"1/4", ADJ WAYS - 55,594 SF
- 219 - Concrete - 19 - COURTYARD PH2 - FIRE LANE, 7"1/4", ADJ WAYS - 15,386 SF
- 228 - Concrete - 20 - SOUTH PARKING LOT - DRIVE ENTRANCE, 7"1/4", ADJ WAYS - 1,267 SF
- 234 - Concrete - 29 - WEST PRACTICE FIELD - PAVE, 4"1/4", CONV. ACCESS ROAD - ADJ WAYS - 11,111 SF
- 235 - Concrete - 25 - VARSITY BASEBALL - FIRE LANE, 7"1/4", ADJ WAYS - 5,796 SF
- 245 - Concrete - 27 - VARSITY SOFTBALL - FIRE LANE, 7"1/4", ADJ WAYS - 5,384 SF
- 252 - Concrete - 26 - JV BASEBALL - FIRE LANE, 7"1/4", ADJ WAYS - 5,613 SF
- 260 - Concrete - 28 - JV SOFTBALL - FIRE LANE, 7"1/4", ADJ WAYS - 4,266 SF
- 43 - Earthwork - 22 - BUS LOOP & PARKING - PAVE - HEAVY (3"1/6") - ADJ WAYS - 9,554 SY ; 85,985 SF
- 45 - Earthwork - 21 - NORTH PARKING LOT - PAVE - HEAVY (3"1/6") - ADJ WAYS - 10,551 SY ; 94,961 SF
- 48 - Earthwork - 20 - SOUTH PARKING LOT - PAVE - HEAVY (3"1/6") - ADJ WAYS - 7,575 SY ; 68,174 SF

- 67 - Earthwork - 35 - OFFSITE ADJ WAYS - PAVE - R/R AC PAVEMENT - 3,482 SY ; 31,334 SF
- 117 - Earthwork - 35 - OFFSITE ADJ WAYS - DEMO - SAWCUT AC PAVEMENT - 5,079 LF
- 118 - Earthwork - 35 - OFFSITE ADJ WAYS - DEMO - REMOVE BARRICADE - 111 LF
- 119 - Earthwork - 35 - OFFSITE ADJ WAYS - UTILITY ADJUSTMENT - 4 EA
- 120 - Earthwork - 35 - OFFSITE ADJ WAYS - PAVE - DEMO AC PAVEMENT - 363 SY ; 3,266 SF
- 121 - Earthwork - 35 - OFFSITE ADJ WAYS - PAVE - AC PAVEMENT - 5,103 SY ; 45,923 SF
- 125 - Earthwork - 35 - OFFSITE ADJ WAYS - DEMO - REMOVE CURB - 108 LF
- 129 - Earthwork - 35 - OFFSITE ADJ WAYS - DEMO - REMOVE IRRIGATION PIPE - 146 LF
- 130 - Earthwork - 35 - OFFSITE ADJ WAYS - DEMO - REMOVE HEADWALL - 5 EA
- 133 - Earthwork - 35 - OFFSITE ADJ WAYS - DEMO - REMOVE CHANNEL LINING - 9,867 SF
- 204 - Earthwork - 22 - BUS LOOP & PARKING - PAVE - HEAVY (3"1/6") - SERVICE YARD, ADJ WAYS - 306 SY ; 2,757 SF
- 69 - Electrical - 35 - OFFSITE ADJ WAYS - RELOCATE OHE - 2 EA
- 126 - Electrical - 35 - OFFSITE ADJ WAYS - STREET LIGHT, 40W LED, x1FTG - 8 EA
- 140 - Electrical - 35 - OFFSITE ADJ WAYS - STREET LIGHT, 133W LED, 40' POLE, x1FTG - 5 EA
- 141 - Electrical - 35 - OFFSITE ADJ WAYS - STREET LIGHT, PULLBOX - 13 EA
- 116 - Landscape - 35 - OFFSITE ADJ WAYS - STABILIZED DG FIRE LANE - 370 SF
- 273 - Landscape - 35 - OFFSITE ADJ WAYS - PLANT 1GAL - 1,647 EA
- 274 - Landscape - 35 - OFFSITE ADJ WAYS - PLANT 5GAL - 1,158 EA
- 275 - Landscape - 35 - OFFSITE ADJ WAYS - TREE 30" BOX (2" CALIPER) - 41 EA
- 276 - Landscape - 35 - OFFSITE ADJ WAYS - DG 3/4" SCREENED - 124,146 SF
- 70 - Wet Utilities - 35 - OFFSITE ADJ WAYS - CATCH BASIN COA A1520 - 7 EA
- 85 - Wet Utilities - 17 - OVERALL GD/PV & UTILITIES - WATER - PIPE 8" PVC C-900 - 74 LF
- 105 - Wet Utilities - 17 - OVERALL GD/PV & UTILITIES - WATER - PIPE 2" COPPER DOMESTIC SERVICE - 295 LF
- 106 - Wet Utilities - 17 - OVERALL GD/PV & UTILITIES - WATER - PIPE 2" LANDSCAPE SERVICE - 296 LF
- 107 - Wet Utilities - 17 - OVERALL GD/PV & UTILITIES - WATER - TSVBC 12"x8" STAINLESS - 1 EA
- 108 - Wet Utilities - 17 - OVERALL GD/PV & UTILITIES - WATER - METER 2" LANDSCAPE - 4 EA
- 109 - Wet Utilities - 17 - OVERALL GD/PV & UTILITIES - WATER - METER 2" DOMESTIC - 4 EA
- 110 - Wet Utilities - 17 - OVERALL GD/PV & UTILITIES - MISC TRAFFIC CONTROL - 1 EA
- 111 - Wet Utilities - 17 - OVERALL GD/PV & UTILITIES - MISC R/R AC PAVEMENT, OFFSITE - 73 SY ; 653 SF
- 127 - Wet Utilities - 35 - OFFSITE ADJ WAYS - STORM - SD 18" HDPE - 341 LF

- 128 - Wet Utilities - 35 - OFFSITE ADJ WAYS - STORM - CB MAG 535 TYPE F - 2 EA
- 136 - Wet Utilities - 35 - OFFSITE ADJ WAYS - WATER - PIPE 2" COPPER DOMESTIC SERVICE - 86 LF
- 137 - Wet Utilities - 35 - OFFSITE ADJ WAYS - WATER - METER 2" DOMESTIC - 1 EA
- 138 - Wet Utilities - 35 - OFFSITE ADJ WAYS - SEWER - MH 5' - 1 EA
- 139 - Wet Utilities - 35 - OFFSITE ADJ WAYS - SEWER - PIPE 6" VCP - 104 LF
- 142 - Wet Utilities - 35 - OFFSITE ADJ WAYS - IRRIGATION - 36" RGRCP - 858 LF

LEGEND


 Fire Hydrant - See Civil Drawings for Fire Lane Plan

 FDKB

Fire Department Key Box

 Fire Department Connection

 Fire Lane

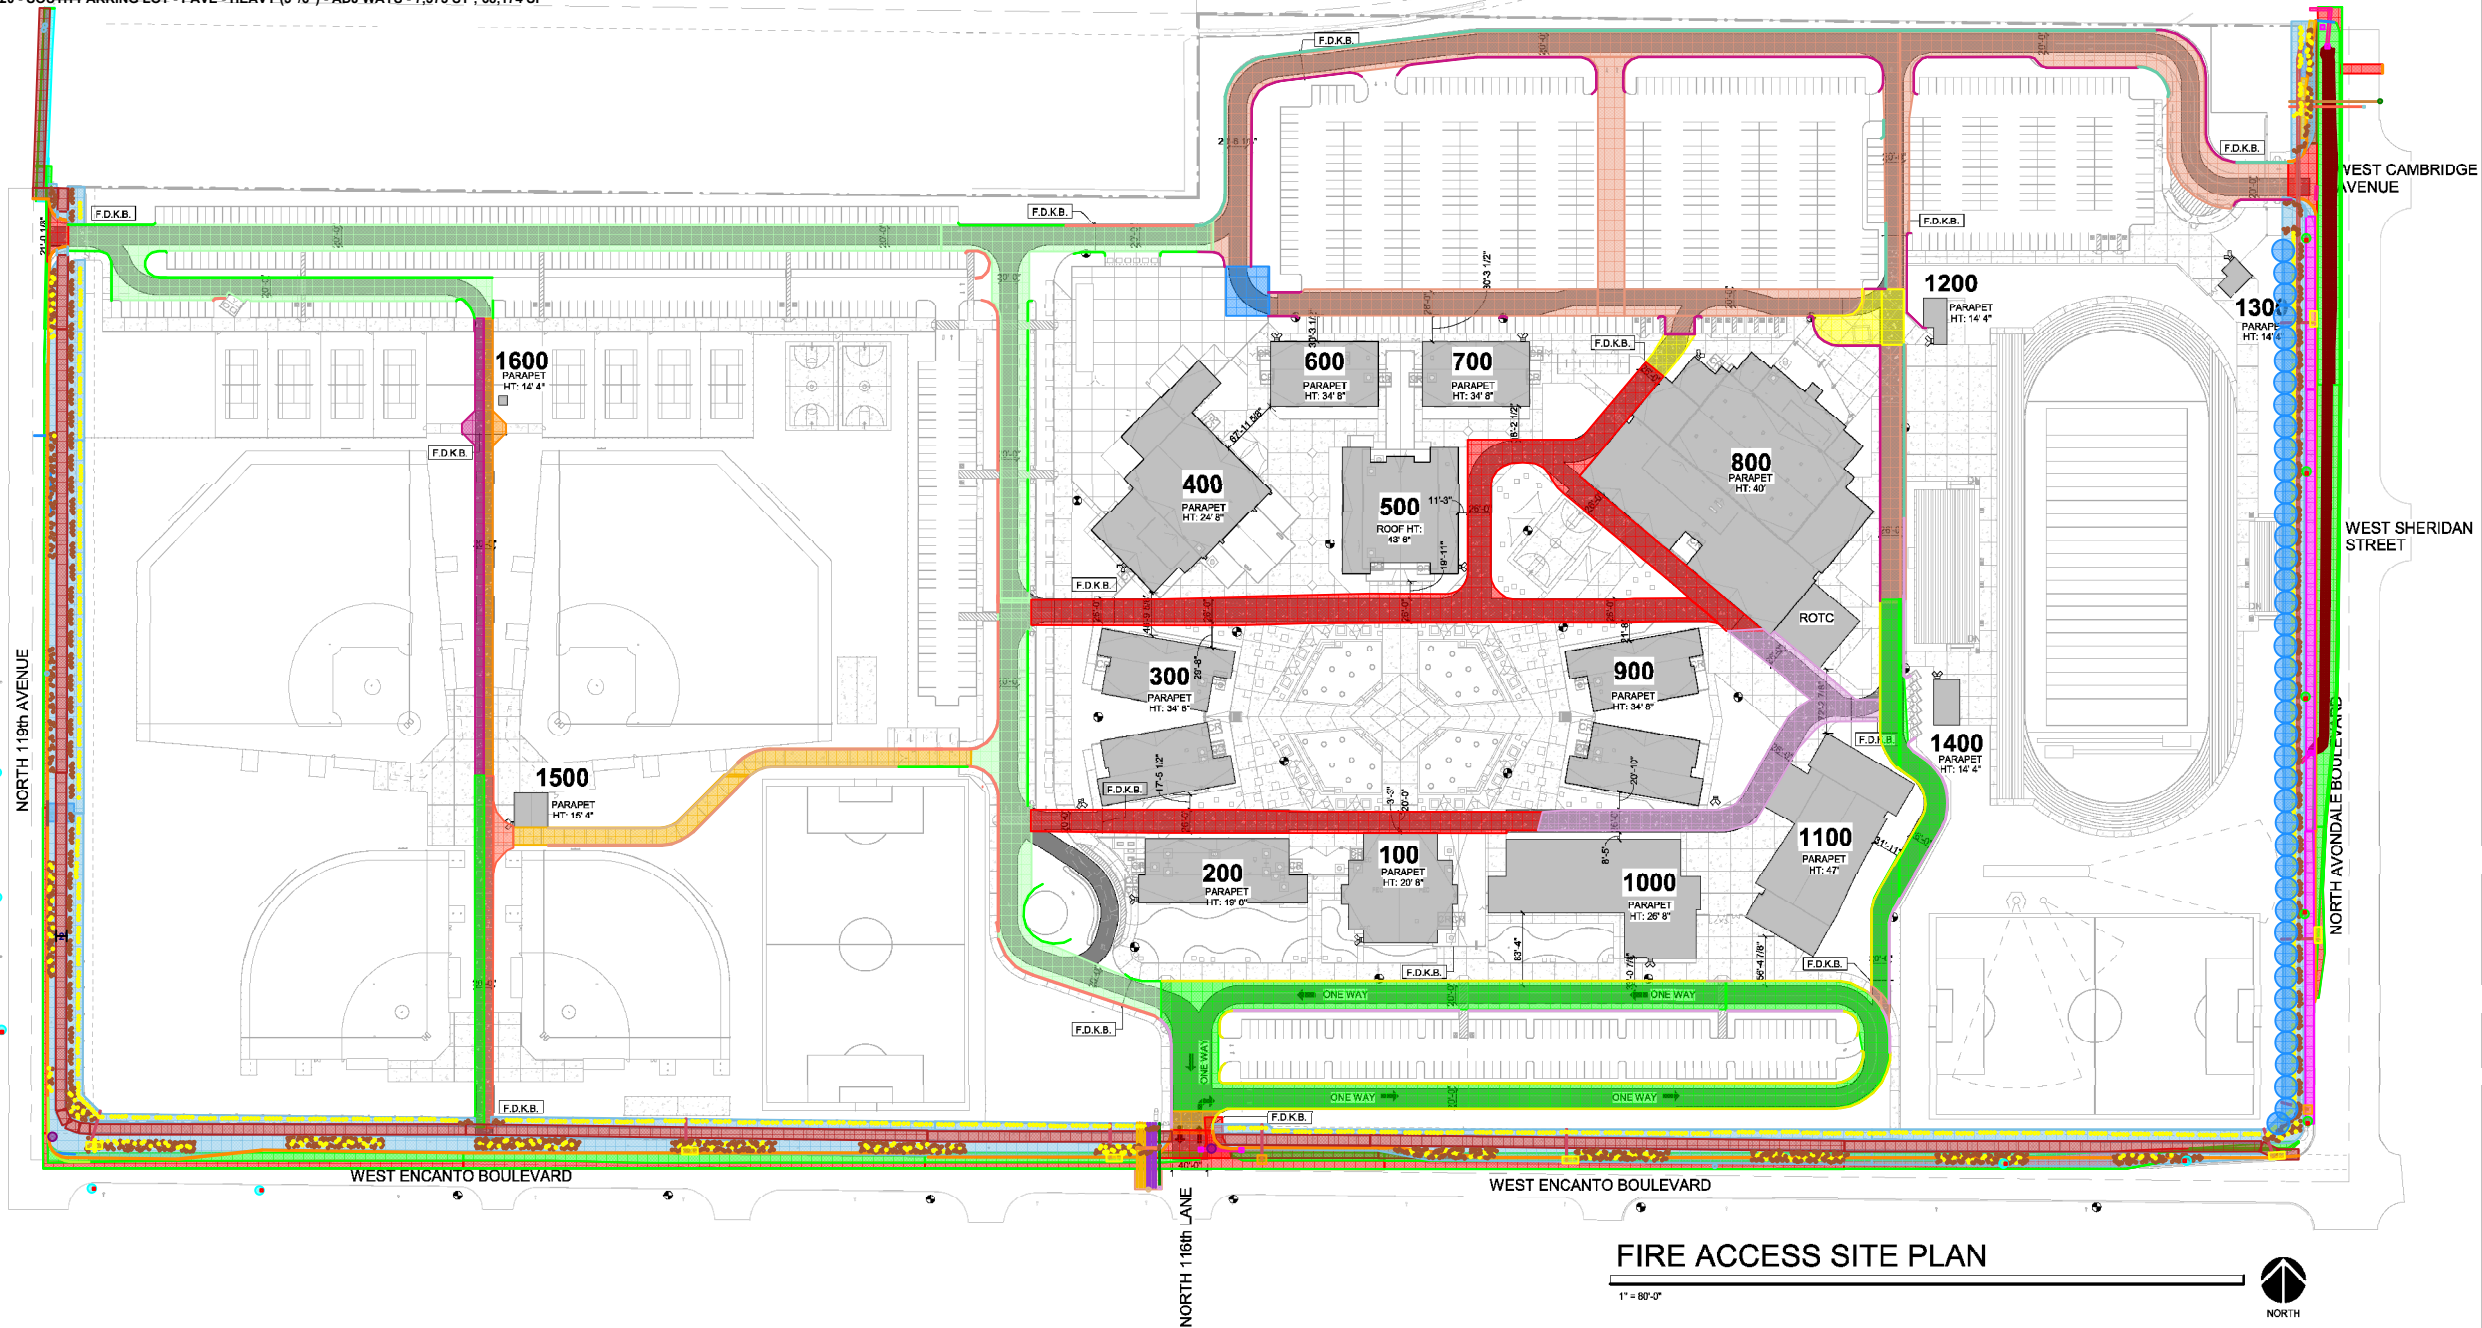

FIRE ACCESS SITE PLAN

1" = 80'-0"



TOLLESON UNION
HIGH SCHOOL DISTRICT
9801 WEST VAN BUREN STREET
TOLLESON, AZ 85333

NEW HIGH SCHOOL #7

REVISION DATE DESCRIPTION

Project Number
8982-100

Date
07/03/18

Drawn By
P. J. S.

Checked By
J.W.

FIRE LANE ACCESS

A0.5

adm group

2100 West 15th Street | Suite 100 | Phoenix, AZ 85001
Tel: 602.282.3500 | Fax: 602.282.3501

SPB# 070514000-9999-006N



ADAM J. SMITH, P.E.