

CHANGE ORDER REQUEST

To:

No. COR 094R-3

Date

Project # 180046

Project Name Tolleson Union High School No 7

Project Manager Connor Lewis

Scope Description

Additional Days

Provide additional trenching and conduit in Right of Way along Encanto Blvd as required by regulatory agencies (SRP), adjacent to the school's property for overhead to underground conversion of Electrical Power. Also added additional conduits for Cox/CenturyLink for future expansion.

Job Code	Cost Code	Description	Amount
180046-15	26110	Urban - SRP Overhead to Underground Conversion along Encanto	128,779.68
180046-15	70100	Liability Insurance	1,287.80
180046-15	70400	Builders Risk Insurance	455.24
180046-15	70500	Payment & Performance Bonds	1,435.75
180046-15	79999	Contractor Fee	7,178.54
180046-15	70600	Gross Receipts Tax	7,958.64

Change Order Request Total \$ 147,095.65

NOTE:

Unless clarified above, CHASSE Building Team reserves the right to evaluate and/or revise the scheduled completion date and review general conditions for the project based on the cumulative impact of this and other changes in the future.

CONTRACTOR

OWNER

ARCHITECT

CHASSE Building Team

Submitted By:

Approved By:

Approved By:



Connor Lewis

cc:

Date: _____ Date: _____



© Copyright, YYYY, HILGARTWILSON, LLC - This plan document set is the sole property of HILGARTWILSON, LLC. No alterations to these plans, other than adding "as-built" information, are allowed by anyone other than authorized HILGARTWILSON, LLC employees.

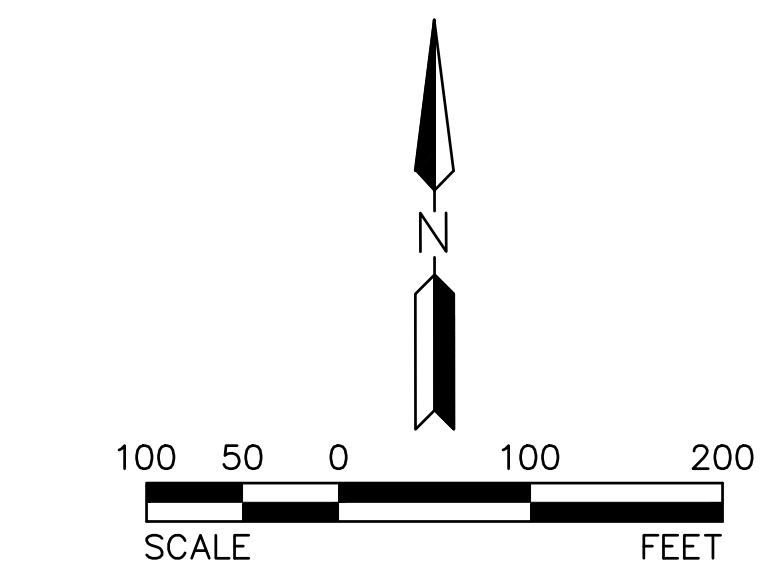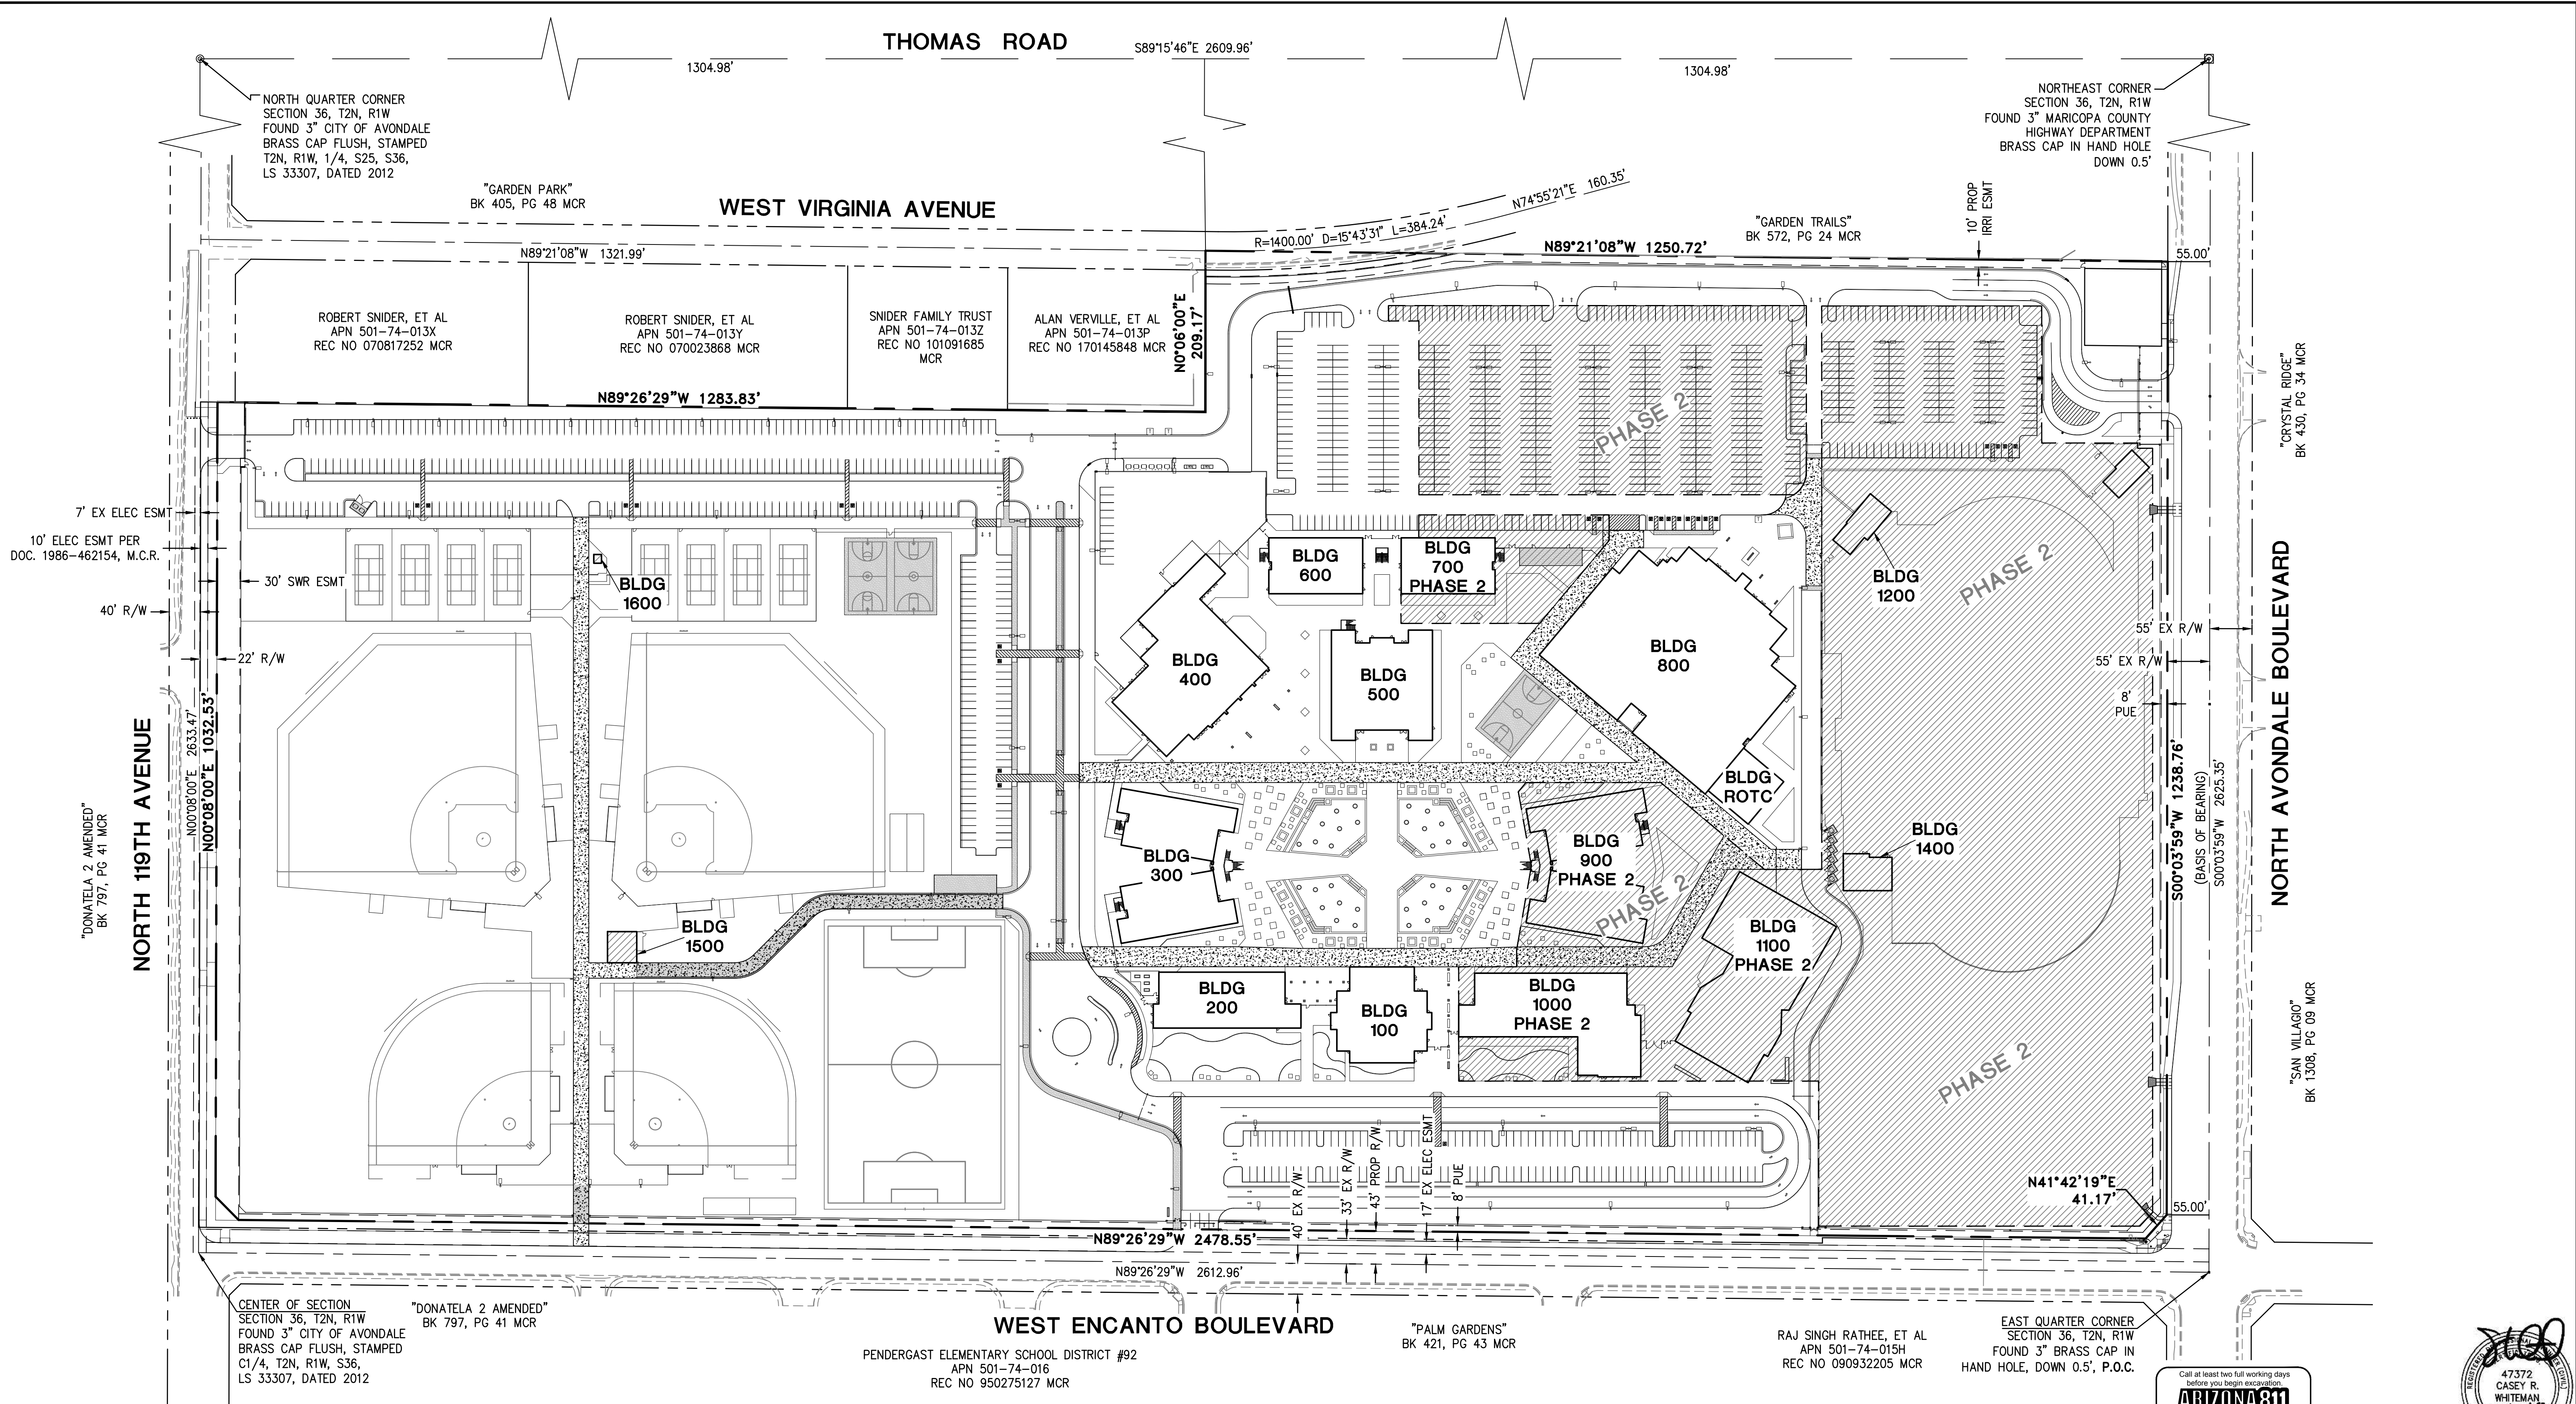

FOR REFERENCE ONLY

Call at least two full working days before you begin excavation!

ARIZONA 811

Arizona Blue State, Inc.

Dial 8-1-1 or 1-800-STAKE-IT (1-800-782-5348)

In Maricopa County, (602) 253-1100

47372
CASEY R.
WHITEMAN
REGISTERED
ARIZONA U.S.A.
Expires 03/31/2020

TOLLESON HIGH SCHOOL #7





11620 WEST ENCANTO BLVD
AVONDALE, ARIZONA

OVERALL CIVIL SITE PLAN

PROJ. NO.	1959	
DATE:	AUGUST 2018	
SCALE:	1" = 100'	HILGARTWILSON
DESIGNED: JW	DRAWN: CM	APPROVED: CW
REV.		
		DWG. NO.
		C1.0
		SHT. X OF X

MAINLINE

SCALE: 1" = 40'

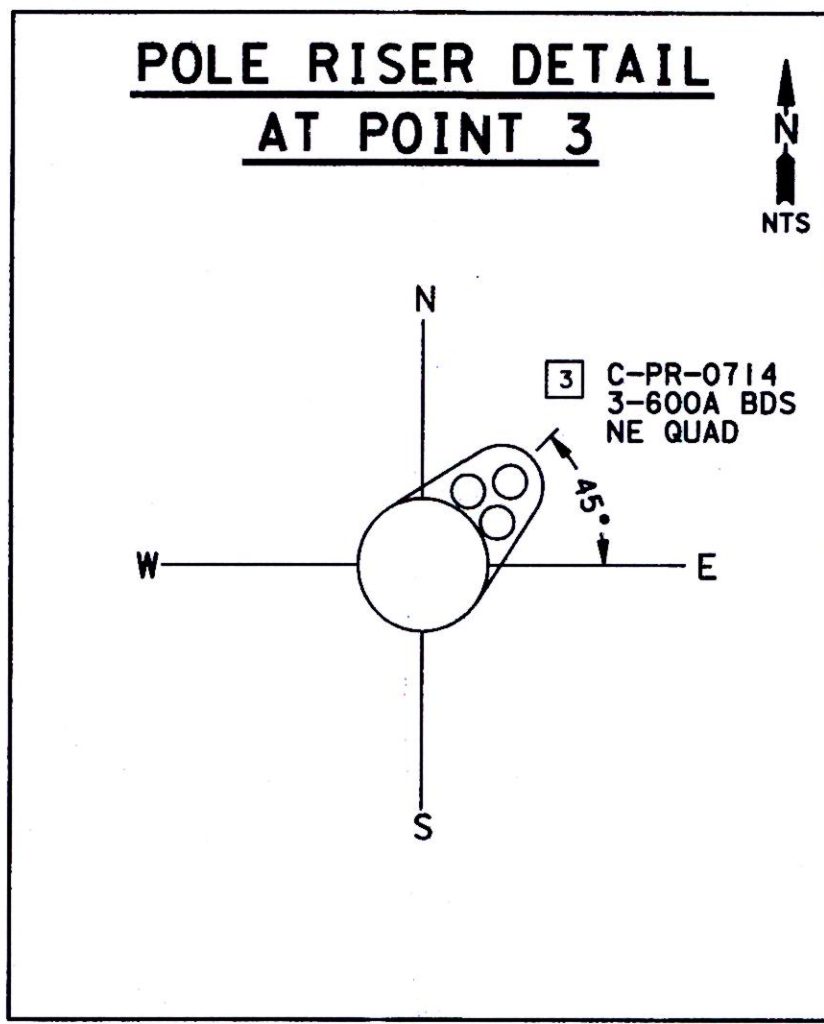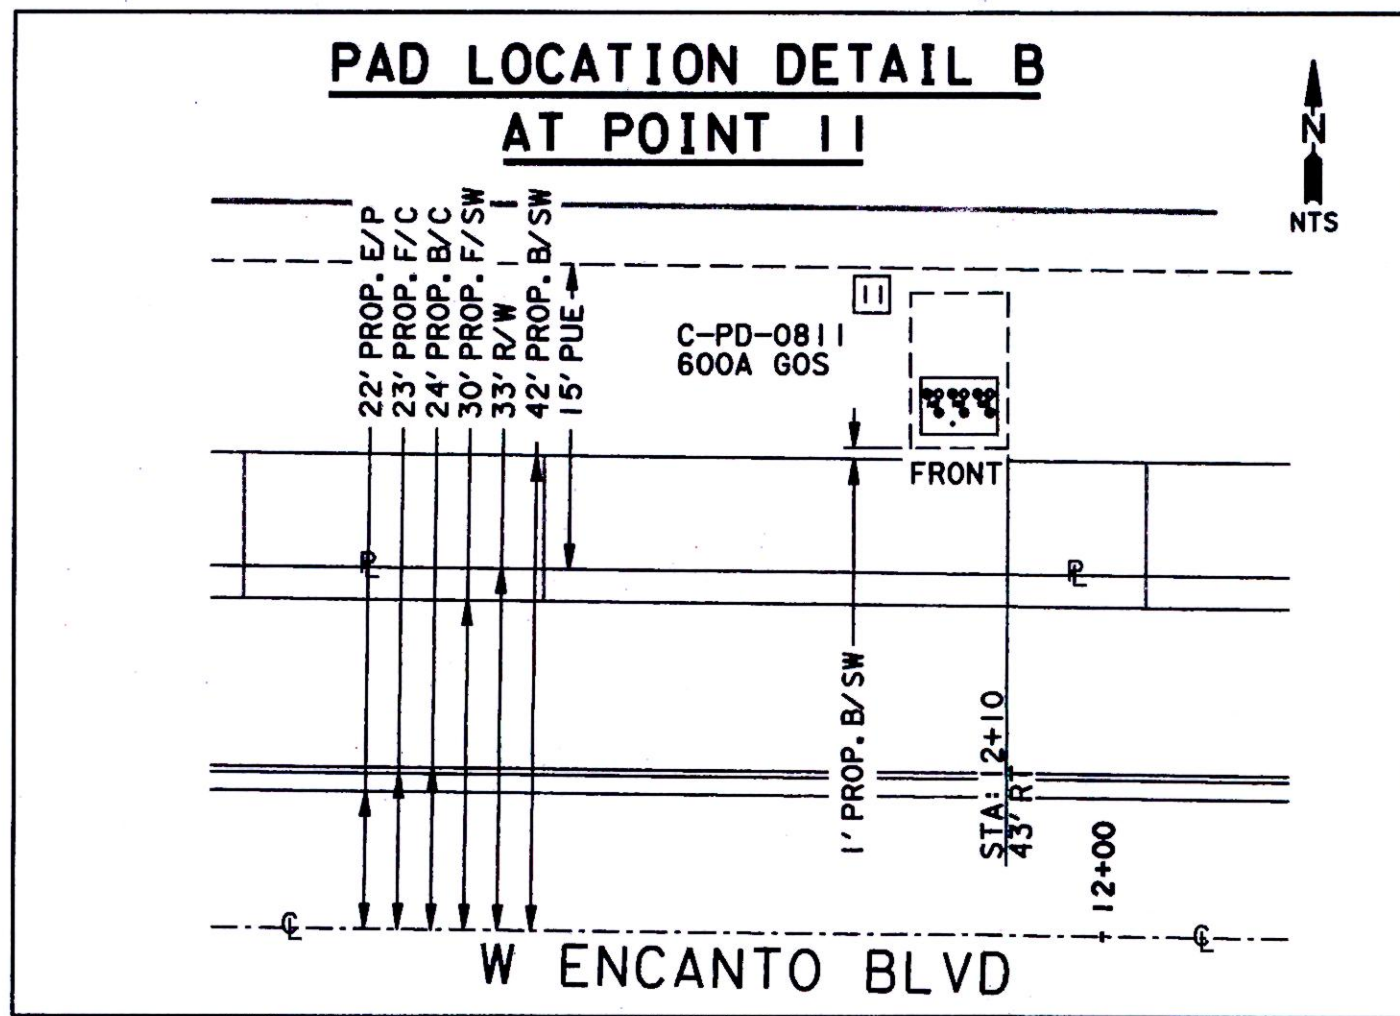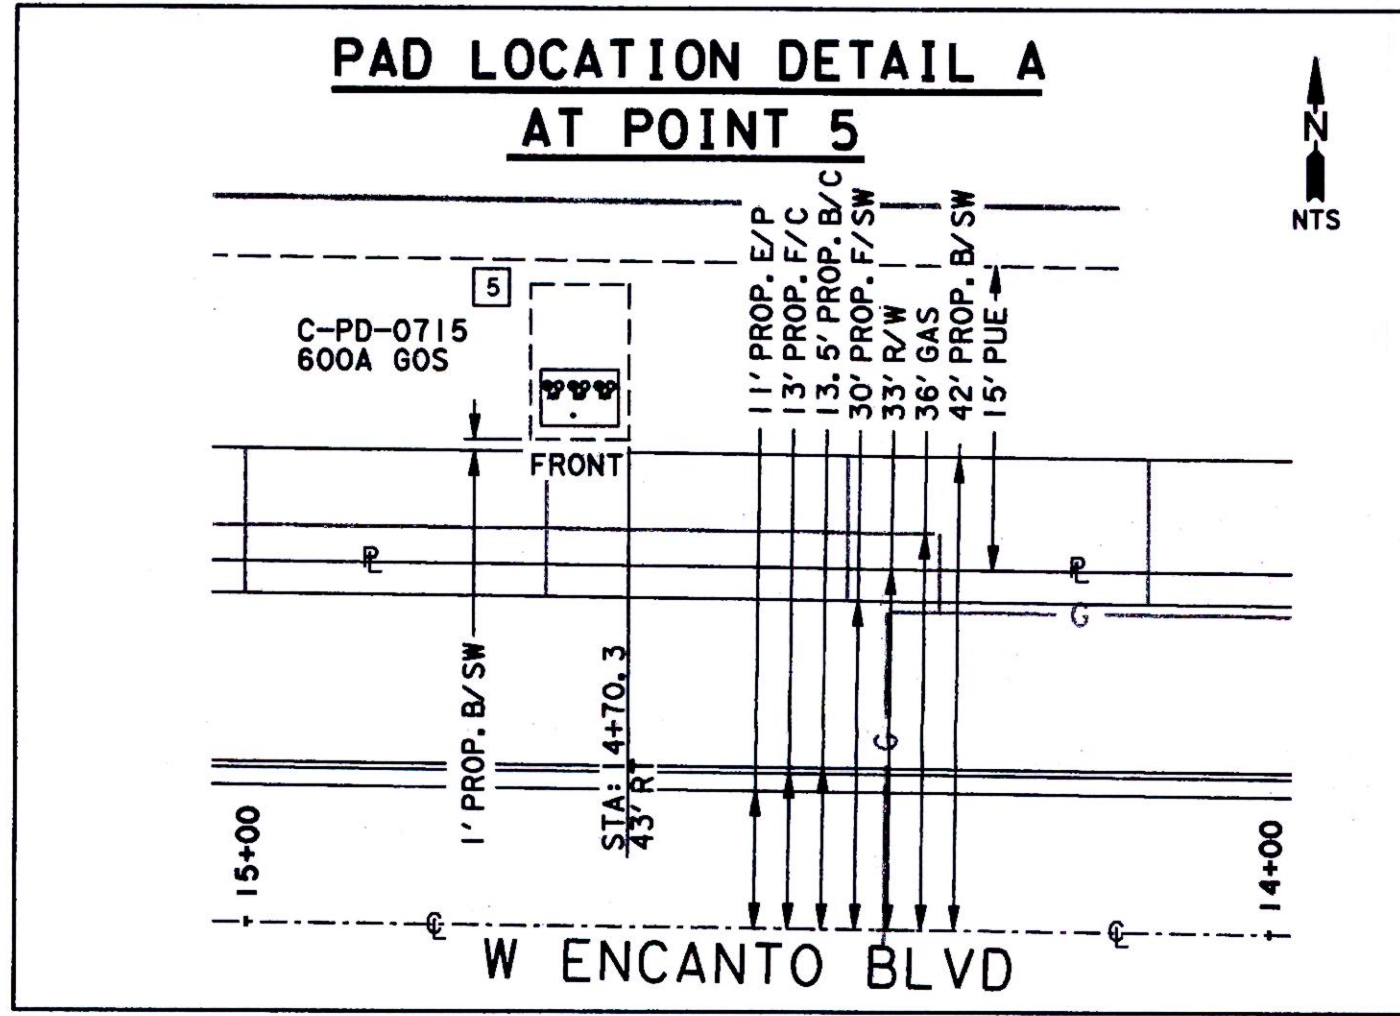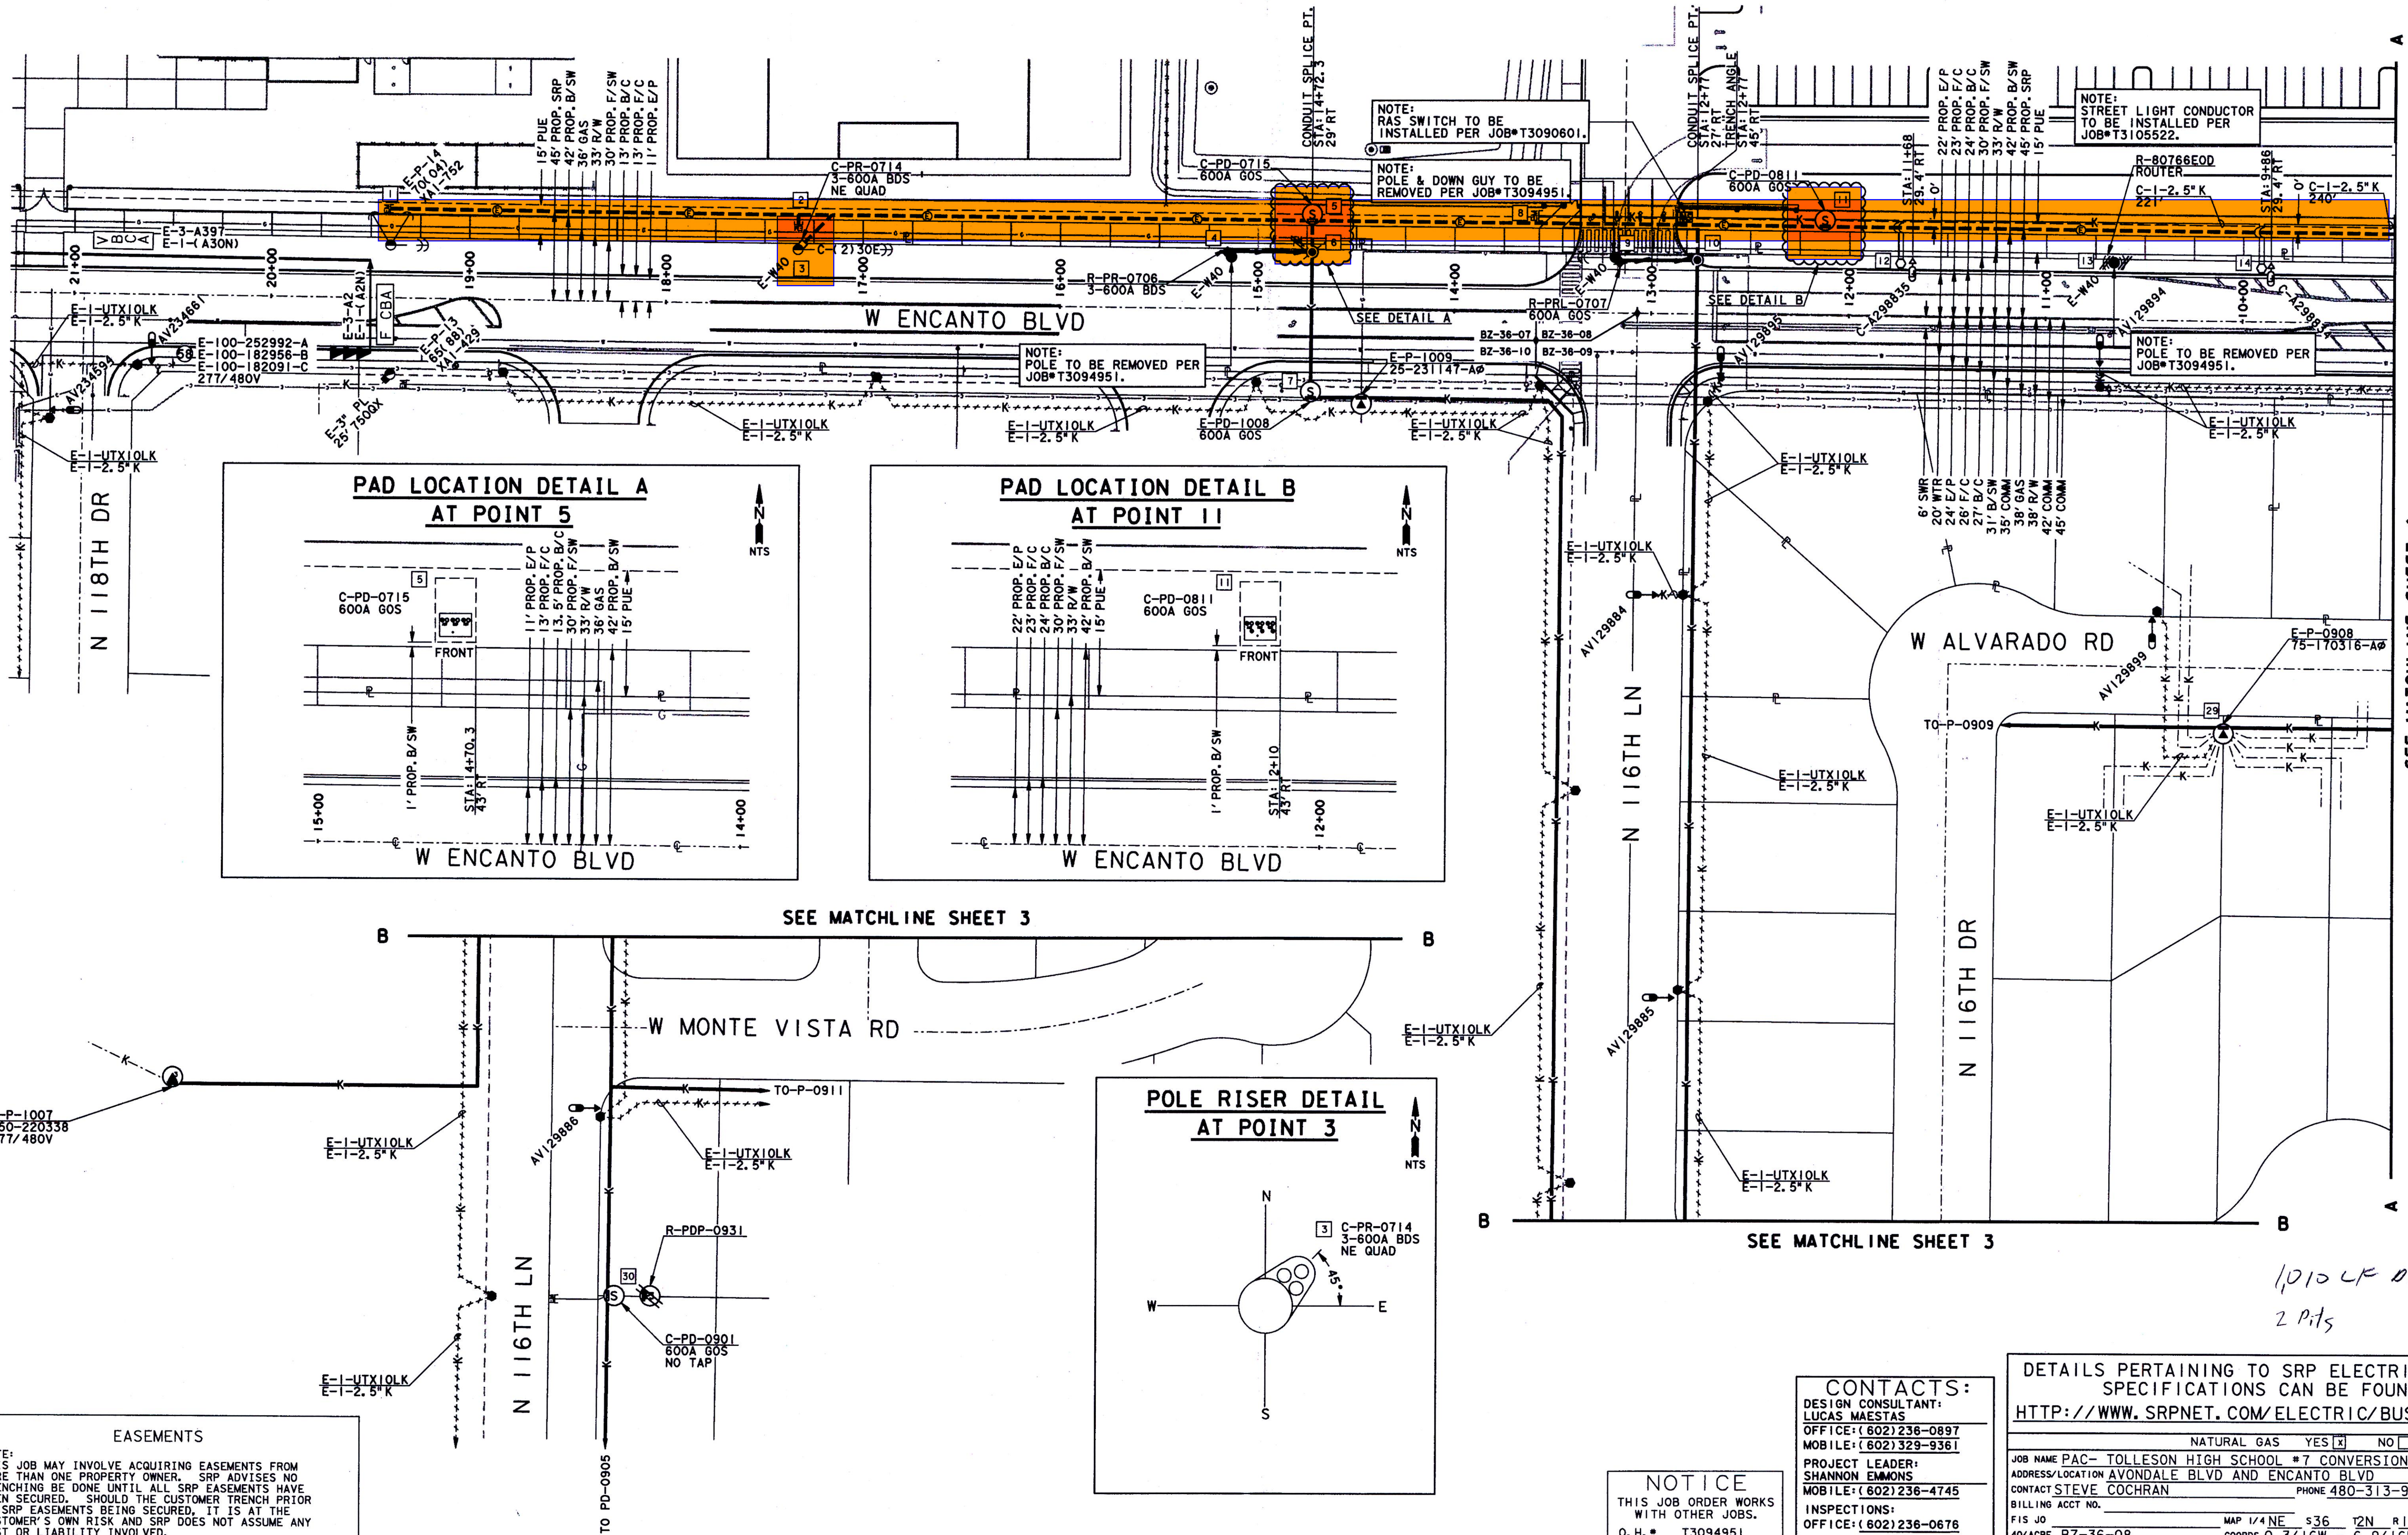

EASEMENTS

NOTE:
THIS JOB MAY INVOLVE ACQUIRING EASEMENTS FROM MORE THAN ONE PROPERTY OWNER. SRP ADVISES NO TRENCHING BE DONE UNTIL ALL SRP EASEMENTS HAVE BEEN SECURED. SHOULD THE CUSTOMER TRENCH PRIOR TO SRP EASEMENTS BEING SECURED, IT IS AT THE CUSTOMER'S OWN RISK AND SRP DOES NOT ASSUME ANY COST OR LIABILITY INVOLVED.

NOTICE

THIS JOB ORDER WORKS WITH OTHER JOBS.

O.H.* T3094951
N.B.* T3090601
ST/LT* T3105522

CONTACTS:

DESIGN CONSULTANT:
LUCAS MAESTAS
OFFICE: (602) 236-0897
MOBILE: (602) 329-9361

PROJECT LEADER:
SHANNON EMMONS
MOBILE: (602) 236-4745

INSPECTIONS:
OFFICE: (602) 236-0676

CONSTRUCTION CONSULTANT:
MONK JOHNSON
MOBILE: (602) 527-3005

DETAILS PERTAINING TO SRP ELECTRICAL SERVICE SPECIFICATIONS CAN BE FOUND AT:
[HTTP://WWW.SRPNET.COM/ELECTRIC/BUSINESS/SPECS/](http://www.srpnet.com/electric/business/specs/)

NATURAL GAS YES ☒ NO ☐

JOB NAME PAC- TOLLESON HIGH SCHOOL #7 CONVERSION
ADDRESS/LOCATION AVONDALE BLVD AND ENCANTO BLVD
CONTACT STEVE COCHRAN PHONE 480-313-9589
BILLING ACCT NO. _____

FIS JO _____ MAP 1/4 NE S36 T2N R1W
40/ACRE BZ-36-08 COORDS 0 3/16W - 6 9/16N
AMP NO T3094945 AMP VERSION _____
COST CENTER 22640
ROUTING CODE DDY+12

SRP


22634frm JD2 02-01-2016

SHEET NUMBER 3 OF 6

MAINLINE

SCALE: 1" = 40'

SEE MATCHLINE SHEET 3

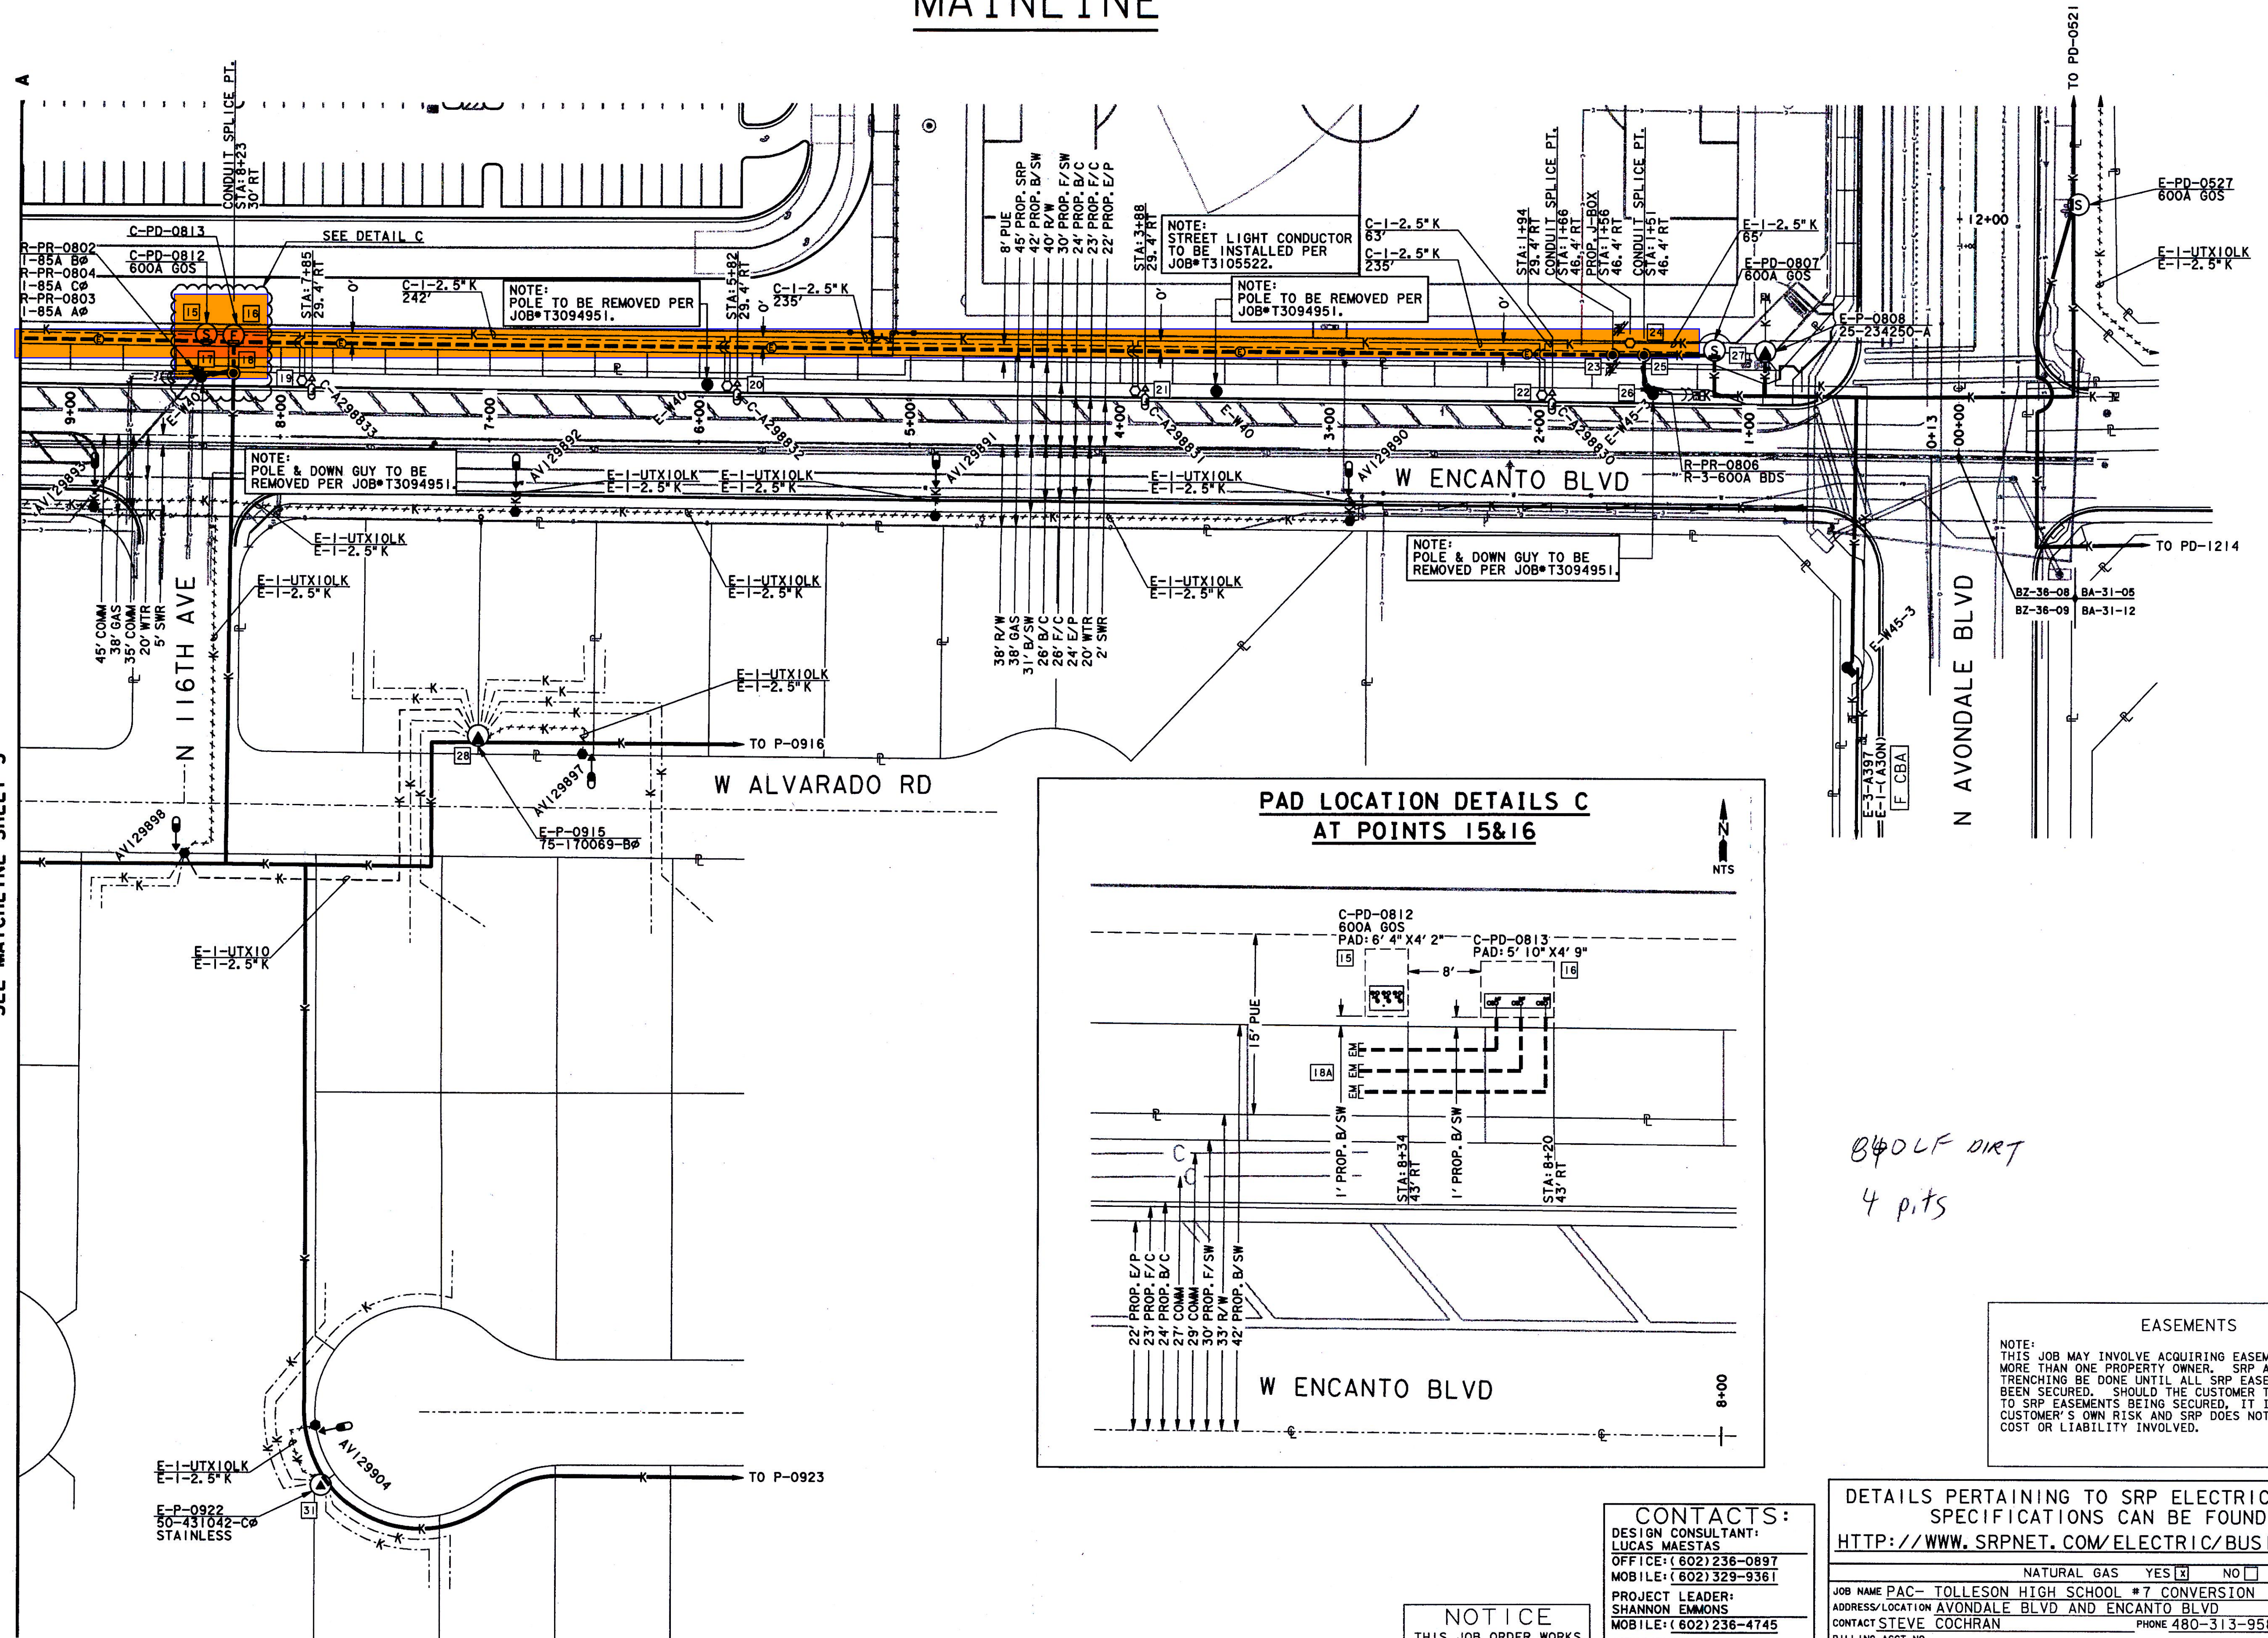

NOTICE
 THIS JOB ORDER WORKS WITH OTHER JOBS.
 O.H.# T3094951
 N.B.# T3090601
 ST/LT# T3105522

CONTACTS:
 DESIGN CONSULTANT:
 LUCAS MAESTAS
 OFFICE: (602) 236-0897
 MOBILE: (602) 329-9361
 PROJECT LEADER:
 SHANNON EMMONS
 MOBILE: (602) 236-4745
 INSPECTIONS:
 OFFICE: (602) 236-0676
 CONSTRUCTION CONSULTANT:
 MONK JOHNSON
 MOBILE: (602) 527-3005

DETAILS PERTAINING TO SRP ELECTRICAL SERVICE SPECIFICATIONS CAN BE FOUND AT:
[HTTP://WWW.SRPNET.COM/ELECTRIC/BUSINESS/SPECS/](http://www.srpnet.com/electric/business/specs/)

NATURAL GAS YES ☒ NO ☐

JOB NAME PAC- TOLLESON HIGH SCHOOL #7 CONVERSION
ADDRESS/LOCATION AVONDALE BLVD AND ENCANTO BLVD
CONTACT STEVE COCHRAN **PHONE** 480-313-9589
BILLING ACCT NO.
FIS JO MAP 1/4 NE S36 T2N R1W
40/ACRE BZ-36-08 **COORDS** 0 3/16W - 6 9/16N
AMP NO T3094945 **AMP VERSION**
COST CENTER 22640
ROUTING CODE DDY+T2

ARTZONABT
 100% SATISFACTION GUARANTEED
 800-848-8888

SRP

SHEET NUMBER 4 OF 6
 22x34Tm J02 02-01-2016