


MATCHLINE SEE SHEET C1.2

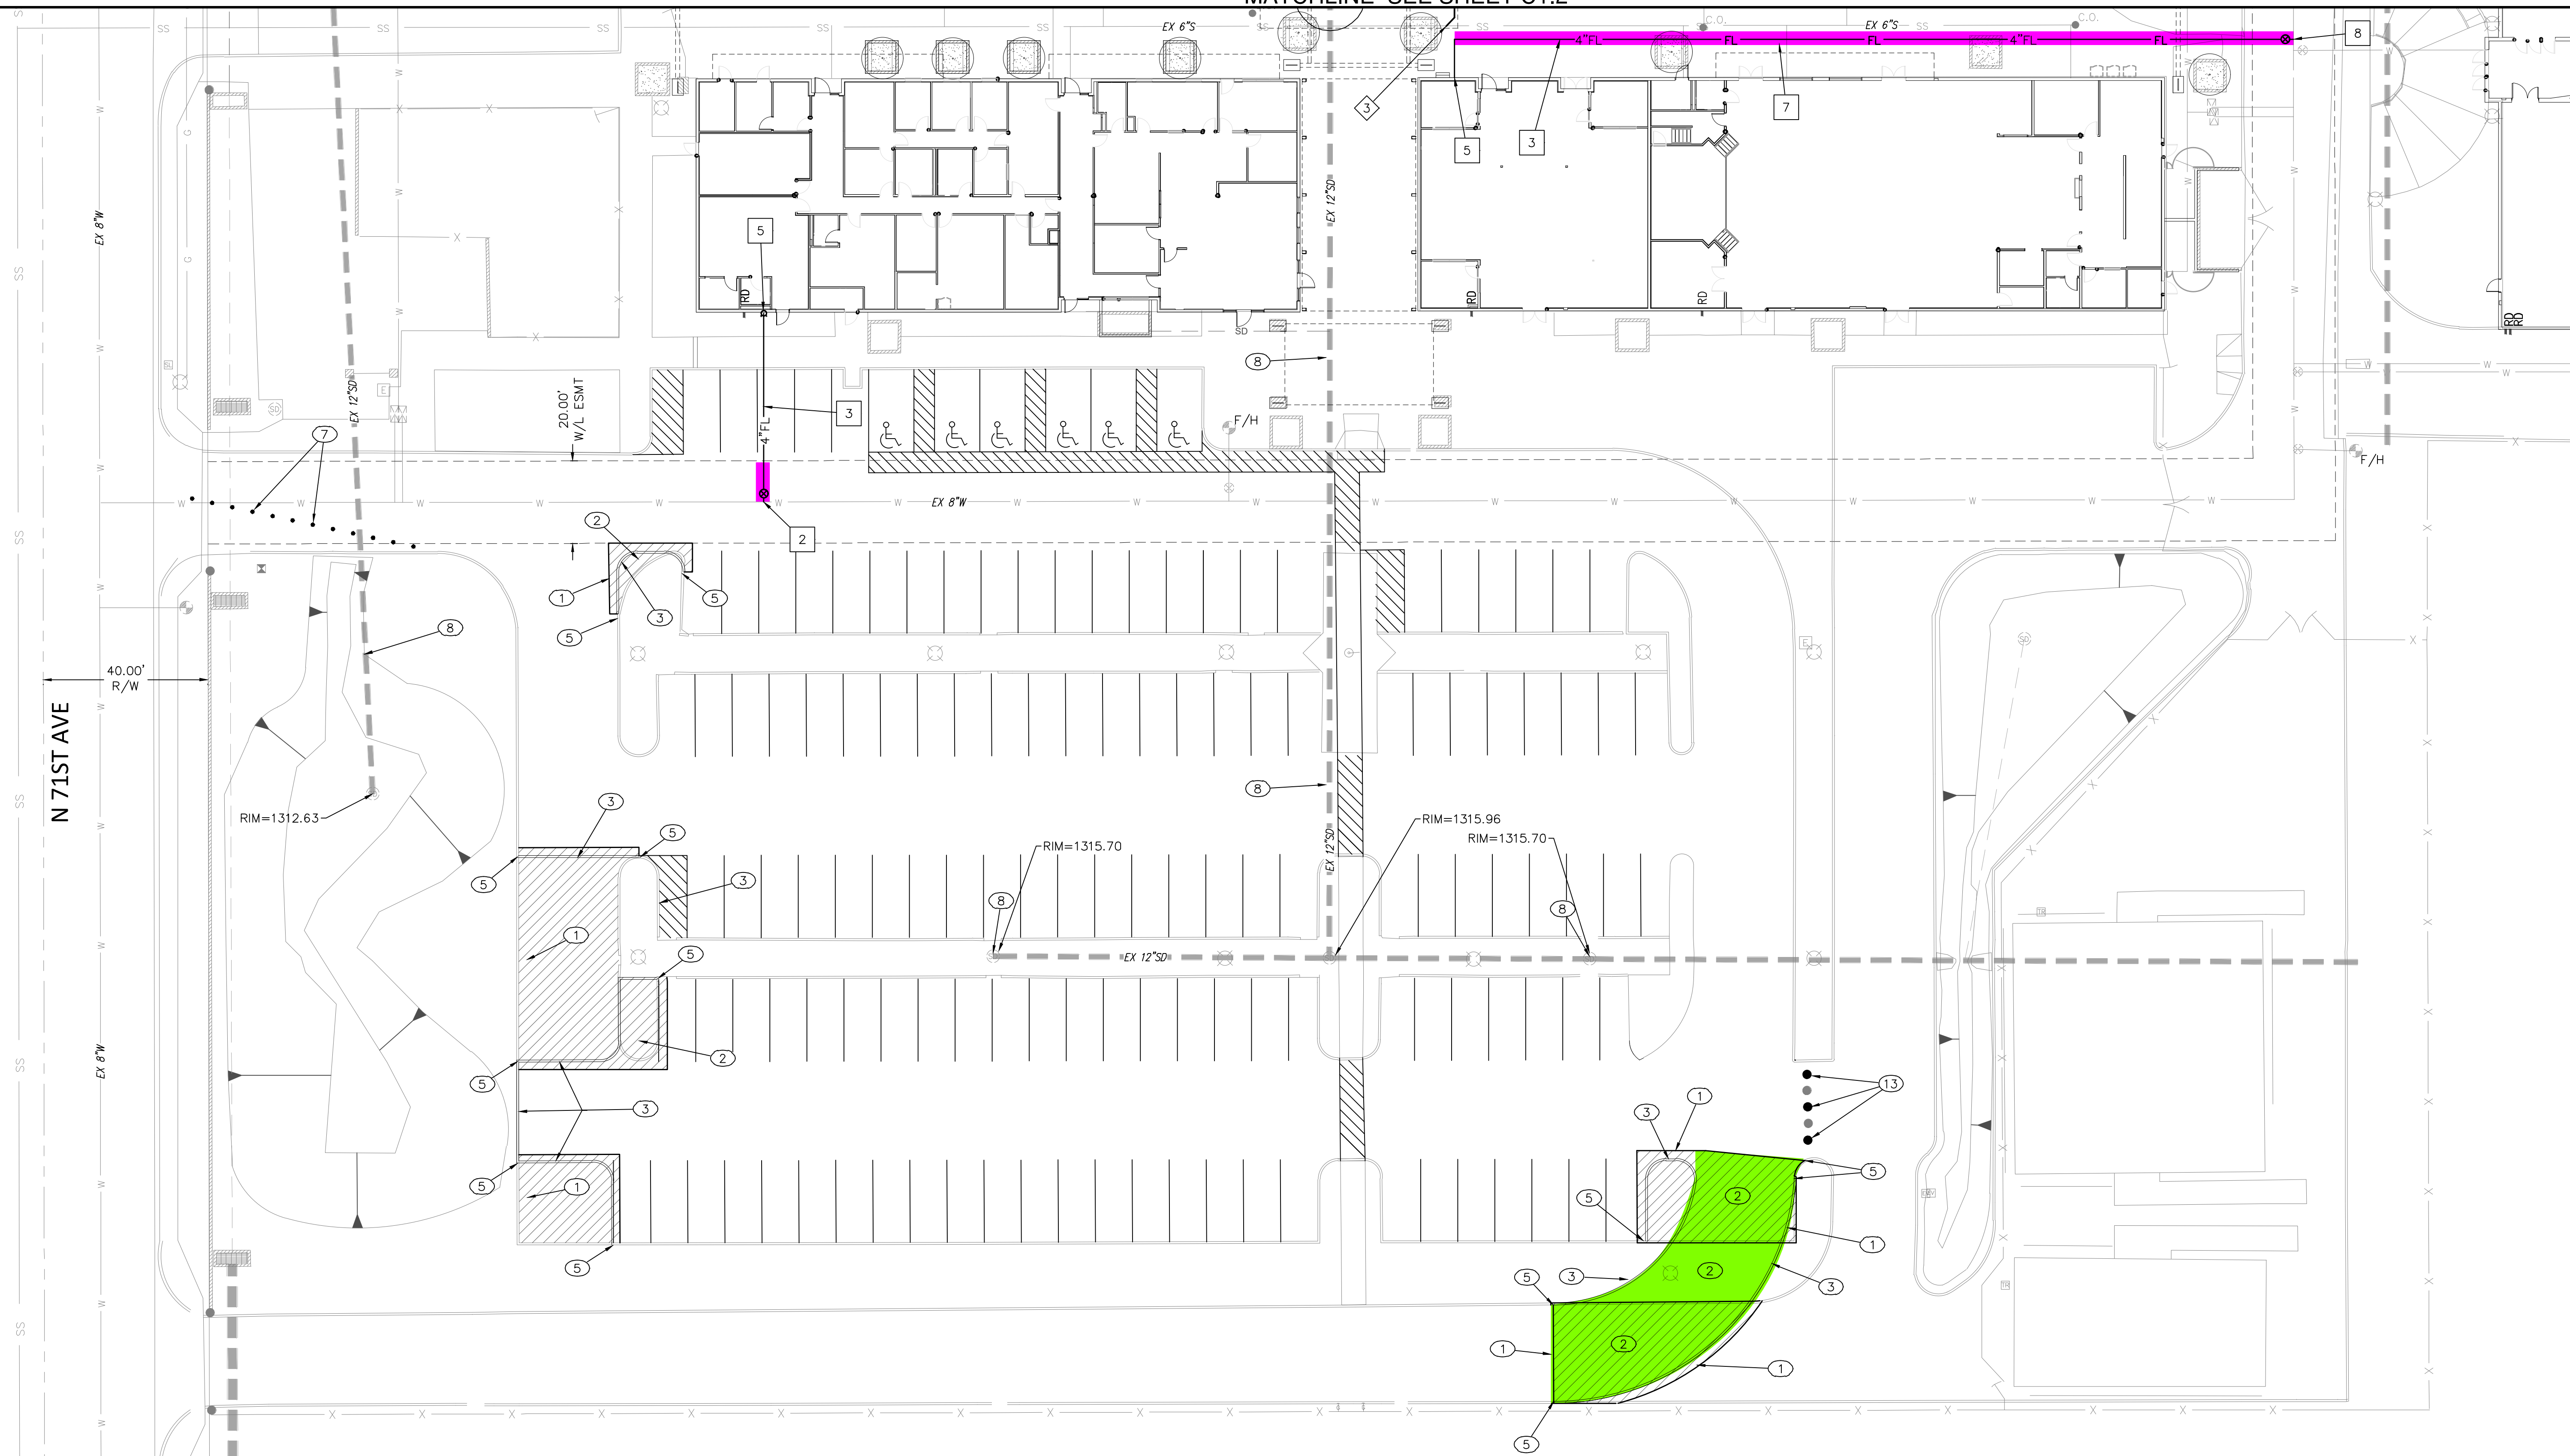


- FIRE LINE**
- 2 CONSTRUCT 8" BY 4" TAPPING SLEEVE, VALVE BOX AND COVER PER MAG STD. DET. 340. NEW FIRELINE TO BE DUCTILE IRON PIPE ENCASED IN POLYETHYLENE TUBE IN ACCORDANCE WITH AWWA C105 AND C600 WITHIN THE PUBLIC RIGHT OF WAY/EASEMENT. PAVEMENT REPLACEMENT AND TRENCH BACKFILL TO BE PER CITY GLENDALE STD.DET. G-319 AND G-390.
 - 3 INSTALL C900 PVC CLASS 200 FIRE LINE, SIZE AS SHOWN.
 - 5 INSTALL FIRE SPRINKLER RISER DETAIL WITH WALLMOUNT FD CONNECTION PER CITY OF GLENDALE STD. DET. G-378.
 - 7 SAWCUT REMOVE AND REPLACE EXISTING CONCRETE MATCHING EXISTING.
 - 8 CONSTRUCT 8" BY 4" TAPPING SLEEVE, VALVE, BOX AND COVER PER MAG STD. DET. 340.

- GRADING AND DRAINAGE**
- 1 SAWCUT EXISTING PAVEMENT TO NEAT EDGE AND REMOVE IMPROVEMENTS WITHIN THE AREA OF NEW CONSTRUCTION.
 - 2 CONSTRUCT NEW 2" (D-1/2) A.C. PAVEMENT ON 6" A.B.C.
 - 3 CONSTRUCT NEW SINGLE CURB PER MAG STD. DET. 222, TYPE "A".
 - 5 MATCH EXISTING IMPROVEMENTS
 - 6 REMOVE EXISTING PAVING AND CURBING IN THIS AREA FOR LANDSCAPING
 - 7 INSTALL FLEXIBLE DELINEATORS AT 5 FEET ON CENTER FOR RIGHT TURN ONLY EXIT.
 - 8 EXISTING STORM DRAIN SYSTEM TO BE CLEANED OUT OF ALL DEBRIS.
 - 13 INSTALL NEW BOLLARDS AT 4 FOOT ON CENTER PER MAG. STD. DET. 140.

- SEWER**
- 3 CONNECT TO EXISTING 6" SEWER.

Adjacent Ways Funding Legend


- Repair of fire lane from construction of fire sprinkler line
- Revision of Fire Lane

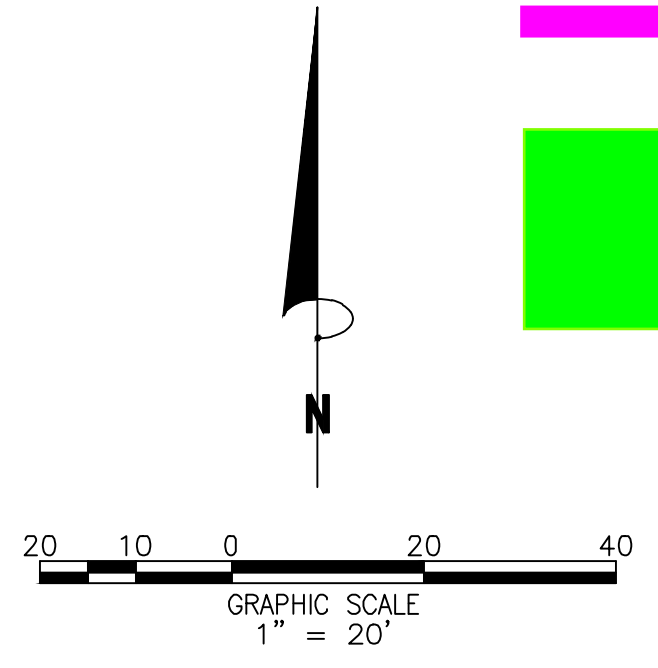

THE PROMPT PAY LAW WILL BE ALTERED FOR THIS CONTRACT NOTICE OF EXTENDED PAYMENT PROVISION THE CONSTRUCTION CONTRACT WILL ALLOW THE OWNER TO MAKE PAYMENT WITHIN THIRTY (30) DAYS AFTER CERTIFICATION AND APPROVAL OF BILLINGS



PROJECT NUMBER

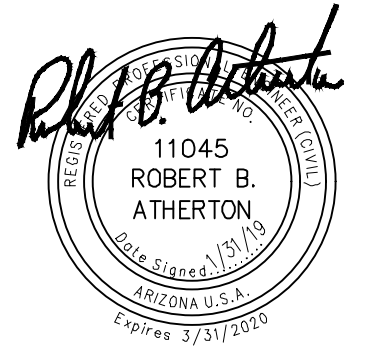

PLAN STATUS

DATE	DESCRIPTION
DESIGN	RLS
DRAWN	RBA
CHKD	CHKD
SCALE	H: 1"=20'
	V: N/A
JOB No.	050600-01-01
DATE :	JAN 31, 2019

C1.3