


COPYRIGHT © 2021 ATWELL LLC. NO REPRODUCTION SHALL BE MADE WITHOUT THE PRIOR WRITTEN CONSENT OF ATWELL LLC.

\\20004730 - deer valley elementary school #32.dwg\\plan sets\\concept\\20000357.aud1.dwg Pldate: 2/28/2021

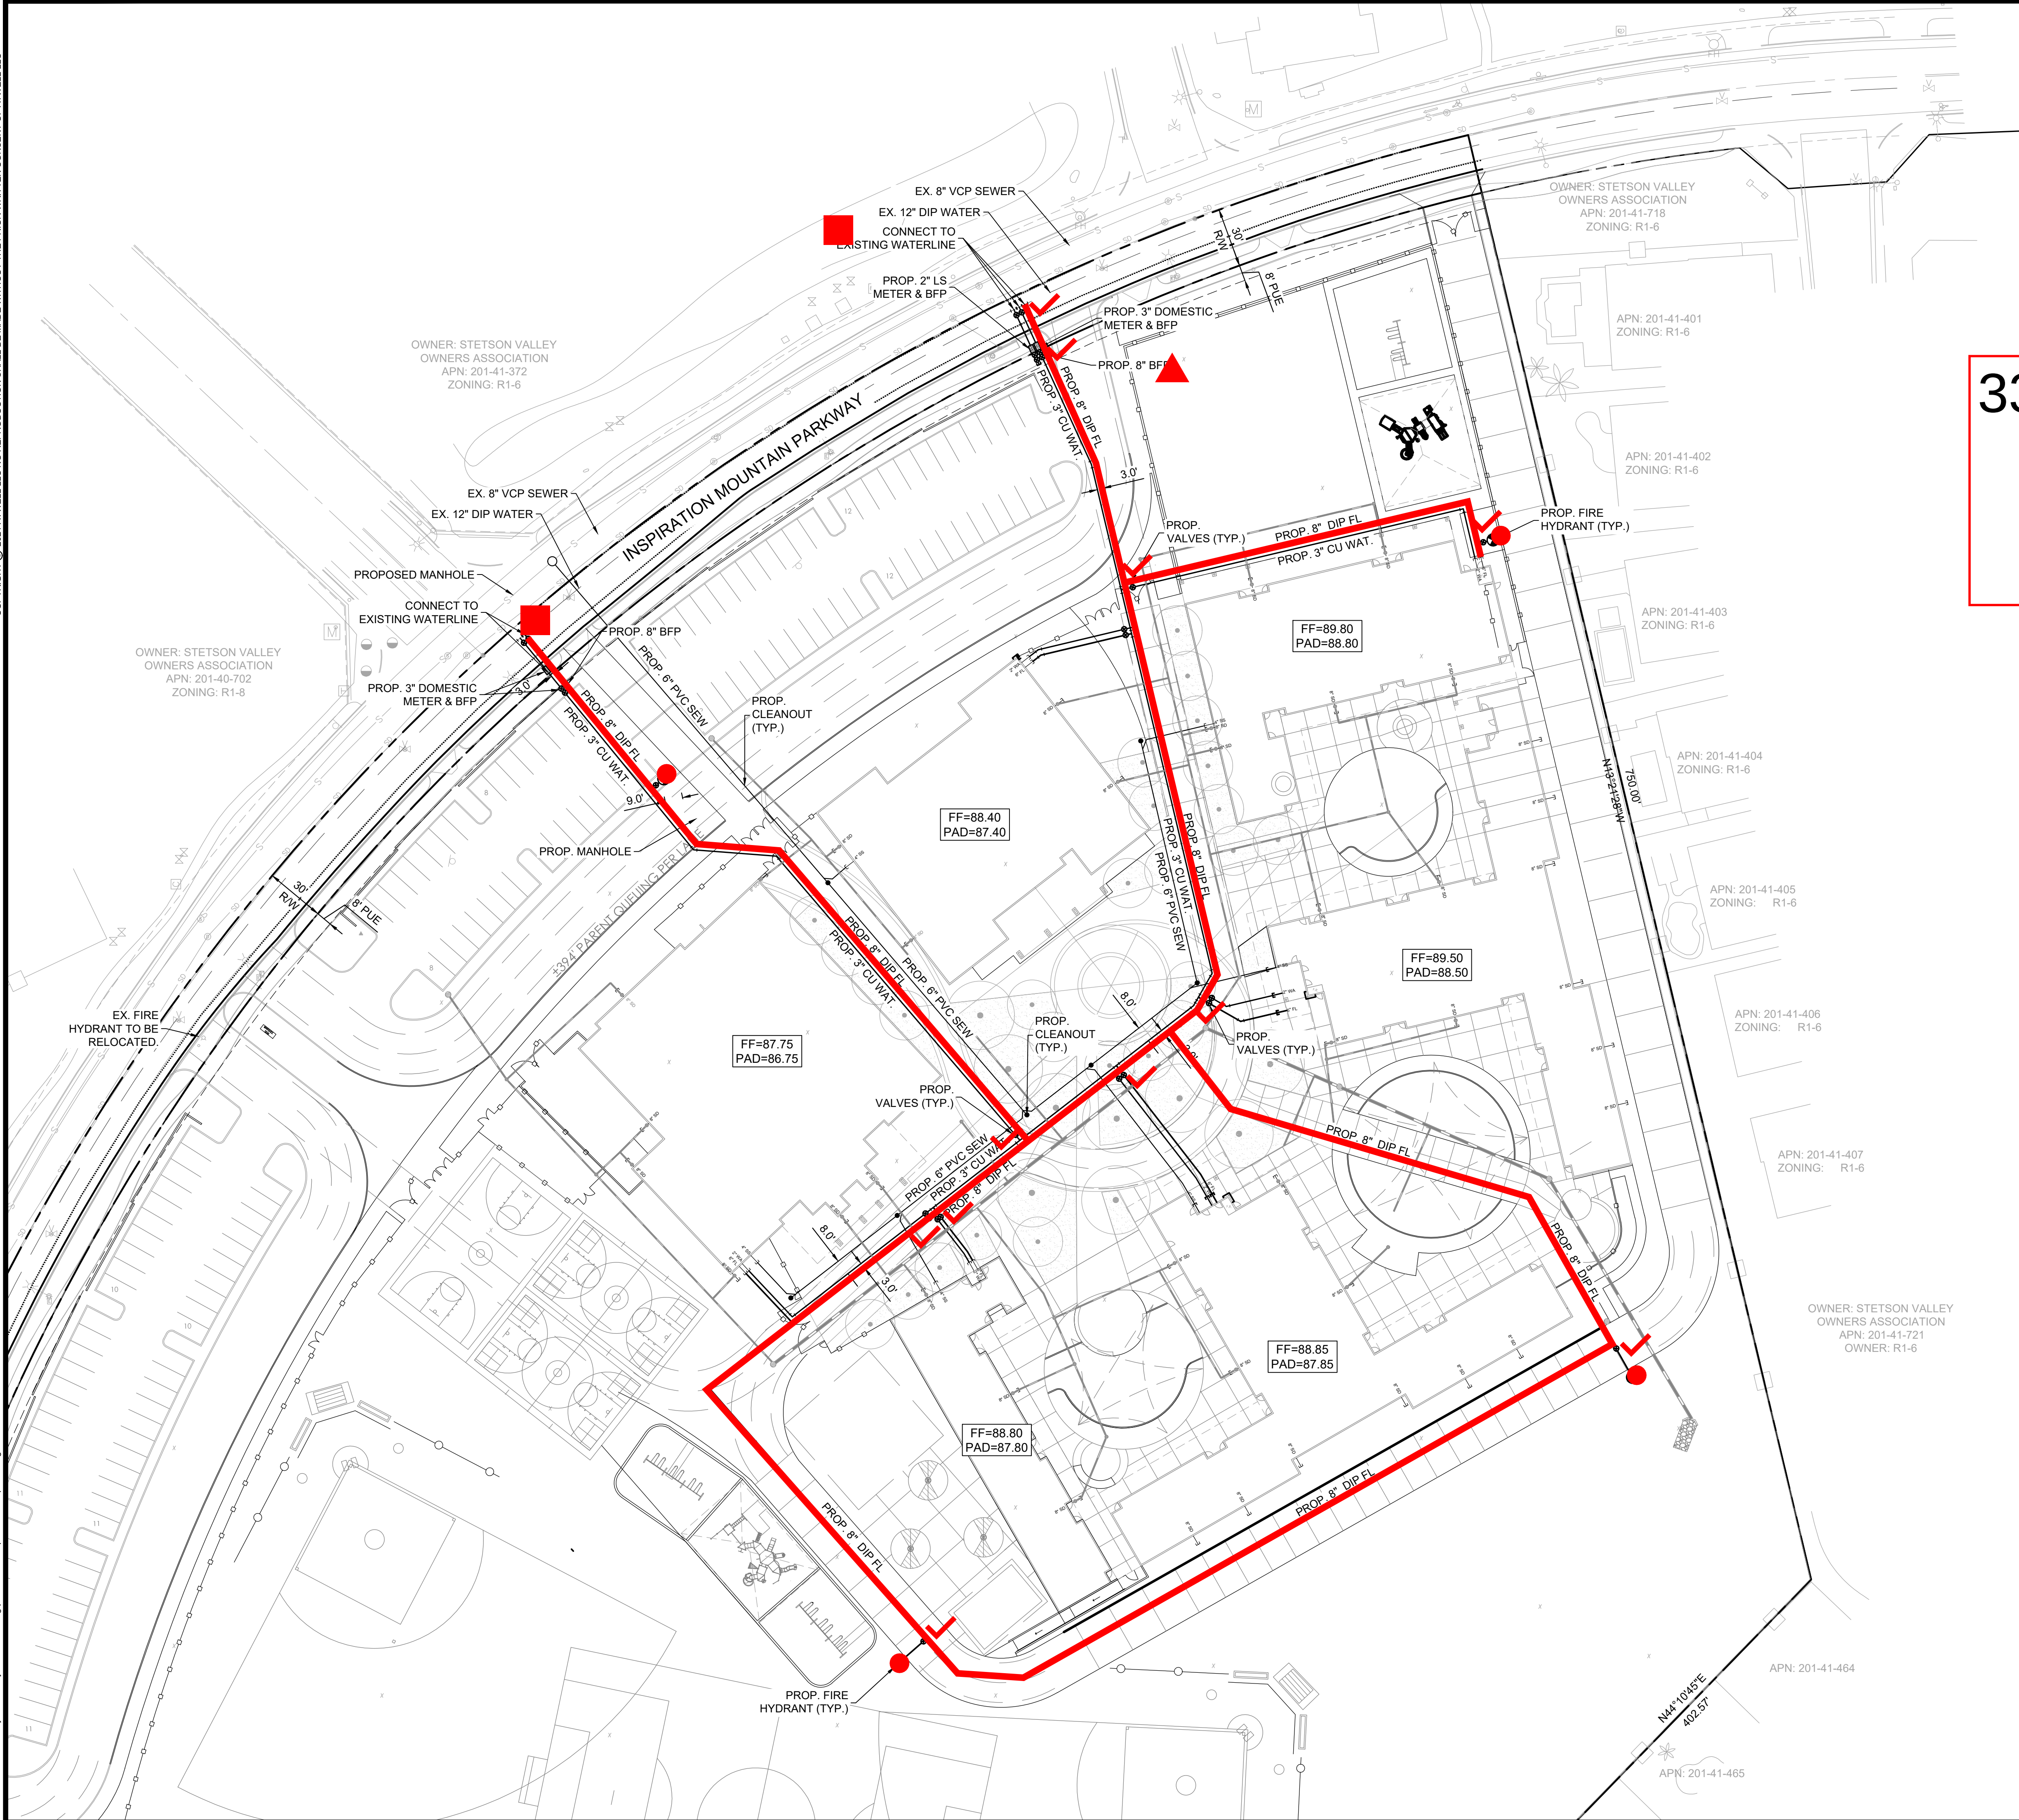

33A Water/Fire/Sewer

- 8" fireline
- 8" VB&C
- 8x12 TSV
- fire hydrant

THE LOCATIONS OF EXISTING UNDERGROUND UTILITIES ARE SHOWN IN AN APPROXIMATE WAY ONLY AND HAVE NOT BEEN INDEPENDENTLY VERIFIED BY THE OWNER OR ITS REPRESENTATIVE. THE CONTRACTOR SHALL DETERMINE THE EXACT LOCATION OF ALL EXISTING UTILITIES BEFORE COMMENCING WORK, AND AGREE TO BE FULLY RESPONSIBLE FOR ANY AND ALL DAMAGES WHICH MIGHT BE OCCASIONED BY THE CONTRACTOR'S FAILURE TO EXACTLY LOCATE AND PRESERVE ANY AND ALL UNDERGROUND UTILITIES.

NOTICE: CONSTRUCTION SITE SAFETY IS THE SOLE RESPONSIBILITY OF THE CONTRACTOR. NEITHER THE OWNER NOR THE ENGINEER SHALL BE EXPECTED TO ASSUME ANY RESPONSIBILITY FOR SAFETY OF THE WORK, OF ANY NEARBY STRUCTURES, OR OF ANY OTHER PERSONS.

ATWELL
866.850.4200 www.atwell-group.com
4700 E. SOUTHERN AVENUE
MESA, AZ 85206
480.218.8831

CONCEPTUAL UTILITY PLANS
FOR
DEER VALLEY SCHOOL DISTRICT #37
PHOENIX, ARIZONA

811
Know what's below.
Call before you dig.

REVISIONS:

CONCEPTUAL PLAN

PM.	RYG
DR.	GSM
JOB NO.	
FILE NO. 20000060357T01	
SHEET NO. 3 OF 3	

CITY PROJECT #

