


Address: 10000 S Beck Ave, Glendale, AZ 85143
Project: GILLILLAND MIDDLE SCHOOL NEW CONSTRUCTION
Date: 11/10/2021
Drawn by: AS101

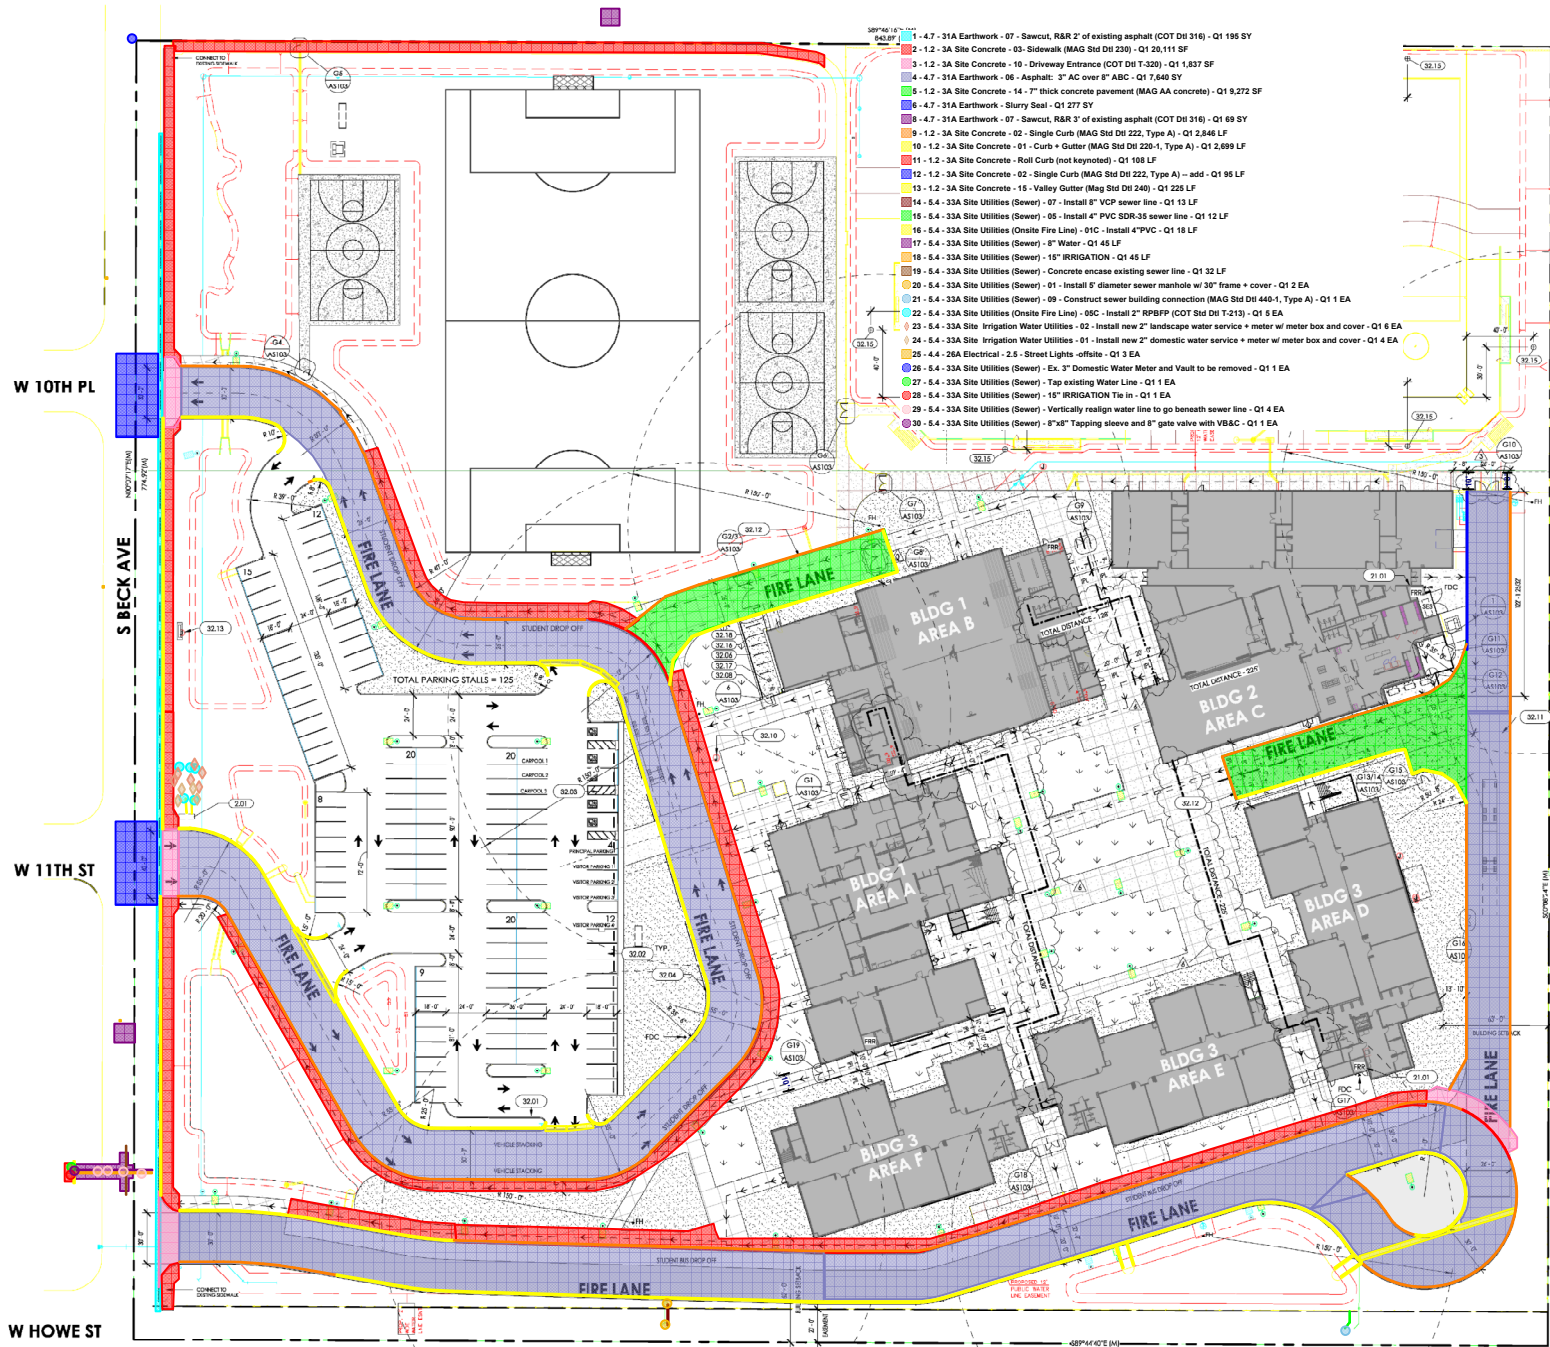

1 SITE PLAN - OVERALL
1" = 32'-0"

KEY NOTES

- 01.01 EXISTING HARDWARE TO BE RELOCATED. PROTECT FROM DAMAGE DURING REMOVAL. SEE ARCHITECTURAL SITE PLAN FOR NEW LOCATION.
- 01.02 FIRE RISER RISER.
- 02.01 NEW 4" VERTICAL CURB. REFER TO CIVIL PLANS & DETAILS.
- 02.02 NEW PARKING STALLS. REFER TO CITY OF TEMPE REQUIREMENTS.
- 02.03 NEW HANDICAP PARKING STALL. STALL PAINTING & SIGNAGE PER CITY OF TEMPE REQUIREMENTS.
- 02.04 PREVENT RILL AND CURB PAINTING. STRUCTURING AND SIGNAGE PER CITY OF TEMPE.
- 02.05 NEW WROUGHT IRON FENCING - COLOR TO BE DETERMINED.
- 02.06 NEW WROUGHT IRON MAIN GATE.
- 02.07 NEW FLAG POLE.
- 02.08 ASPHALT FIRE LANE DRIVE.
- 02.09 CONCRETE FIRE LANE DRIVE.
- 02.10 EXISTING HARDWARE TO BE RELOCATED.
- 02.11 CHAIN LINK FENCE & PROPERTY LINE. REFER TO LANDSCAPE FOR DETAILS.
- 02.12 MUSCO FIELD LIGHT. REFER TO ELECTRICAL PLANS/SPEC. FOR MORE INFO. REFER TO STRUCTURAL FOR POLE FOUNDATION.
- 02.13 BINS BACK. SEE LANDSCAPE DWGS.
- 02.14 SKATEBOARD RACK. SEE LANDSCAPE DWGS.
- 02.15 CONCRETE HEADER. SEE LANDSCAPE DWGS.

SITE HATCHES & SYMBOLS

- ▲ FDC
- Ⓜ FIRE HYDRANT
- FLAG POLE
- WROUGHT IRON FENCING
- FIRE LANE (ASPHALT)
- FIRE LANE (CONCRETE)
- CONCRETE PAVING
- MAGNARY PROPERTY LINE (PL)
- PEDESTRIAN CROSSING PATH TO PUBLIC WAY
- TRAVEL PATH TO PLUMBING FIXTURE

GILLILLAND MIDDLE SCHOOL NEW CONSTRUCTION
TEMPE SCHOOL DISTRICT NO. 3
1025 S BECK AVE, TEMPE, AZ 85281
OVERALL SITE PLAN

THIS DRAWING IS AN INSTRUMENT OF SERVICE & THE PROPERTY OF SP+S ARCHITECTS. IT IS TO BE USED ONLY FOR THE PROJECT AND SITE SPECIFICALLY IDENTIFIED HEREIN. NO REUSE OR REPRODUCTION OF THIS DRAWING IS PERMITTED.

DATE	DESCRIPTION
10/20/21	BLDG FOR GMP
11/10/21	BLDG FOR GMP
11/10/21	BLDG FOR GMP
11/10/21	BLDG FOR GMP
11/10/21	BLDG FOR GMP


REVISION	DATE	DESCRIPTION
1	11/10/21	REVISIONS
2	11/10/21	REVISIONS
3	11/10/21	REVISIONS
4	11/10/21	REVISIONS
5	11/10/21	REVISIONS

REVIEWED BY: ST
DRAWN BY: MD



DATE: 11/30/21
JOB NO: 21008
SHEET: 1

AS101
21008

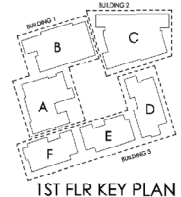

1ST FLR KEY PLAN